

PUBLIC IMPROVEMENT CONSTRUCTION PLANS

COOPER HOOK MAIN PLACE

A PARCEL OF LAND BEING A PORTION OF SECTION 26,
TOWNSHIP 7 SOUTH, RANGE 67 WEST OF THE SIXTH PRINCIPAL MERIDIAN
TOWN OF CASTLE ROCK, COUNTY OF DOUGLAS, STATE OF COLORADO
TOWN OF CASTLE ROCK PROJECT NO. CD26-00XX



Issued for Permits - June 16, 2026
Project Number 2600487

fishbeck.com 1515 Arboretum Drive
800.456.3824 Grand Rapids, Michigan

SHEET INDEX

G-1 TITLE SHEET
D-1 ELECTRICAL DEMOLITION PLAN
E-1 ILLUMINATION PLAN

SYMBOL LEGEND

- EXISTING POLE MOUNTED FIXTURE LOCATION
- ⊕-○ EXISTING BUILDING MOUNTED FIXTURE LOCATION
- ⊗ EXISTING SURFACE MOUNTED FIXTURE LOCATION
- NEW POLE MOUNTED FIXTURE LOCATION
- ⊕-○ NEW BUILDING MOUNTED FIXTURE LOCATION
- ⊗ NEW SURFACE MOUNTED FIXTURE LOCATION
- /// DEMOLITION HATCHING

GENERAL NOTES

- ALL MATERIALS, WORKMANSHIP, AND CONSTRUCTION OF PUBLIC IMPROVEMENTS SHALL MEET OR EXCEED THE STANDARDS AND SPECIFICATIONS SET FORTH IN THE TOWN OF CASTLE ROCK (TCR) MUNICIPAL CODE, TCR TECHNICAL MANUALS, AND APPLICABLE STATE AND FEDERAL REGULATIONS. WHERE THERE IS CONFLICT BETWEEN THESE PLANS AND THE TECHNICAL MANUAL OR ANY APPLICABLE STANDARDS, THE MORE STRINGENT STANDARD SHALL APPLY. ALL WORK SHALL BE INSPECTED AND APPROVED BY THE TCR CONSTRUCTION INSPECTOR.
- THE CONTRACTOR SHALL HAVE ONE (1) SIGNED COPY OF THE APPROVED PLANS, ONE (1) COPY OF THE APPROPRIATE CRITERIA AND SPECIFICATIONS, AND A COPY OF ANY PERMITS AND EXTENSION AGREEMENTS NEEDED FOR THE JOB ONSITE AT ALL TIMES.
- THE CONTRACTOR SHALL BE RESPONSIBLE FOR ALL ASPECTS OF SAFETY INCLUDING, BUT NOT LIMITED TO, EXCAVATION, TRENCHING, SHORING, TRAFFIC CONTROL, AND SECURITY.
- IF DURING THE CONSTRUCTION PROCESS CONDITIONS ARE ENCOUNTERED WHICH COULD INDICATE A SITUATION THAT IS NOT IDENTIFIED IN THE PLANS OR SPECIFICATIONS, THE CONTRACTOR SHALL CONTACT THE TCR CONSTRUCTION INSPECTOR IMMEDIATELY.
- ALL REFERENCES TO ANY PUBLISHED STANDARDS SHALL REFER TO THE LATEST REVISION OF SAID STANDARD UNLESS SPECIFICALLY STATED OTHERWISE.
- THE CONTRACTOR SHALL SUBMIT A TRAFFIC CONTROL PLAN IN ACCORDANCE WITH MUTCD TO THE APPROPRIATE RIGHT-OF-WAY AUTHORITY (TOWN, COUNTY OR STATE) FOR APPROVAL PRIOR TO ANY CONSTRUCTION ACTIVITIES WITHIN OR AFFECTING THE RIGHT-OF-WAY. THE CONTRACTOR SHALL BE RESPONSIBLE FOR PROVIDING ANY AND ALL TRAFFIC CONTROL DEVICES AS MAY BE REQUIRED BY THE CONSTRUCTION ACTIVITIES.
- THE CONTRACTOR IS RESPONSIBLE FOR PROVIDING ALL LABOR AND MATERIALS NECESSARY FOR THE COMPLETION OF THE INTENDED IMPROVEMENTS SHOWN ON THESE DRAWINGS OR AS DESIGNATED TO BE PROVIDED, INSTALLED, OR CONSTRUCTED UNLESS SPECIFICALLY NOTED OTHERWISE.
- THE CONTRACTOR SHALL BE RESPONSIBLE FOR RECORDING AS-BUILT INFORMATION ON A SET OF RECORD DRAWINGS KEPT ON THE CONSTRUCTION SITE AND AVAILABLE TO THE TCR CONSTRUCTION INSPECTOR AT ALL TIMES.
- DIMENSIONS FOR LAYOUT AND CONSTRUCTION ARE NOT TO BE SCALED FROM ANY DRAWING. IF PERTINENT DIMENSIONS ARE NOT SHOWN, CONTACT THE CONSULTANT ENGINEER FOR CLARIFICATION AND ANNOTATE THE DIMENSION ON THE AS-BUILT RECORD DRAWINGS.
- THERE SHALL BE NO SITE CONSTRUCTION ACTIVITIES ON SATURDAYS UNLESS SPECIFICALLY APPROVED BY THE TCR CONSTRUCTION INSPECTOR AND NO SITE CONSTRUCTION ACTIVITIES ON SUNDAYS OR HOLIDAYS UNLESS THERE IS PRIOR WRITTEN APPROVAL BY THE PUBLIC WORKS DIRECTOR.
- PROVIDE A BASIS OF BEARINGS STATEMENT PER COLORADO STATE STATUTE.

FILED CHANGE ORDER TABLE		
FOC#	DATE	PURPOSE/DESCRIPTION

PROJECT TEAM CONTACT INFORMATION

OWNER

HOME DEPOT

PHONE NUMBER: (303) 688-8790
ADDRESS: 333 W Allen St,
Castle Rock, Colorado

CONTRACTOR

NICHOLE BAKER - RELIABLE ELECTRIC AND LIGHTING

PHONE NUMBER: (616) 642-9853 x-114
ADDRESS: 6459 Nash Highway
Saranac, Michigan

ELECTRICAL ENGINEER/PROJECT MANAGER

TONY KUHTZ - FISHBECK


PHONE NUMBER: (616) 464-3722
ADDRESS: 1515 Arboretum Drive
Grand Rapids, Michigan

ELECTRICAL ENGINEER/PLAN PREPARER

OLVIA FILECCIA - FISHBECK

PHONE NUMBER: (248) 324-2128
ADDRESS: 1515 Arboretum Drive
Grand Rapids, Michigan

PROJECT VICINITY MAP

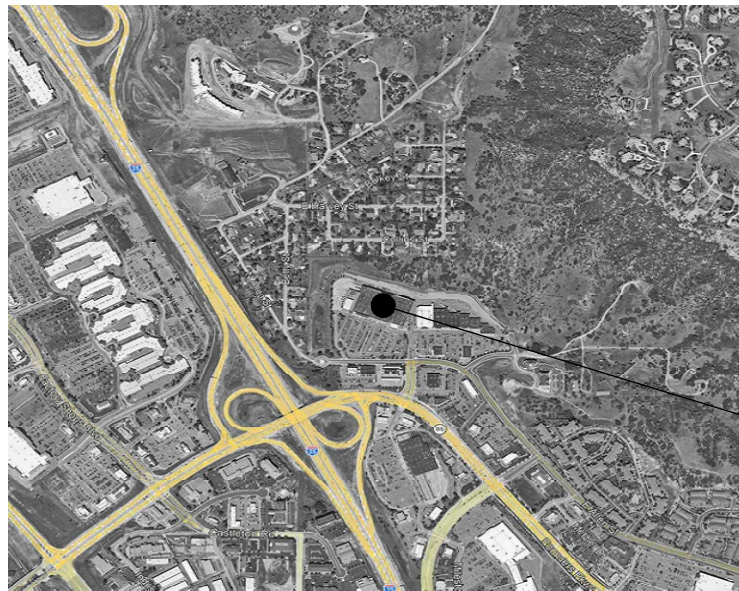

HOME DEPOT



VICINITY MAP
1" = 2000'

IDENTIFICATION AND ADHERENCE TO STANDARDS STATEMENT

THESE PLANS HAVE BEEN REVIEWED BY THE TOWN OF CASTLE ROCK FOR CONCEPT ONLY. THE REVIEW DOES NOT IMPLY RESPONSIBILITY BY THE REVIEWING DEPARTMENT, THE TOWN ENGINEER, OR THE TOWN OF CASTLE ROCK FOR ACCURACY AND CORRECTNESS OF THE CALCULATIONS. FURTHERMORE, THE REVIEW DOES NOT IMPLY THAT QUANTITIES OF ITEMS ON THE PLANS ARE THE FINAL QUANTITIES REQUIRED. THE REVIEW SHALL NOT BE CONSTRUED FOR ANY REASON AS ACCEPTANCE OF FINANCIAL RESPONSIBILITY BY THE TOWN FOR ADDITIONAL QUANTITIES OF ITEMS SHOWN THAT MAY BE REQUIRED DURING THE CONSTRUCTION PHASE.

ALL WORK SHALL BE CONSTRUCTED IN ACCORDANCE WITH THE TOWN OF CASTLE ROCK MUNICIPAL CODE, TECHNICAL MANUALS AND/OR OTHER TOWN-APPROVED APPLICABLE STANDARDS.

TOWN APPROVAL BLOCK

TOWN OF CASTLE ROCK APPROVAL
PLANS ARE HEREBY APPROVED FOR ONE YEAR FROM
DATE OF DEVELOPMENT SERVICES APPROVAL


APPROVED BY:

DEVELOPMENTAL SERVICES DATE

PROFESSIONAL ENGINEER'S CERTIFICATION

I HEREBY AFFIRM THAT THESE FINAL CONSTRUCTION PLANS WERE PREPARED UNDER MY DIRECT SUPERVISION, IN ACCORDANCE WITH ALL APPLICABLE TOWN OF CASTLE ROCK AND STATE OF COLORADO STANDARDS AND STATUTES, RESPECTIVELY, AND THAT I AM FULLY RESPONSIBLE FOR ALL DESIGN AND REVISIONS RELATIVE TO SAID PLANS.

ENGINEER SIGNATURE DATE

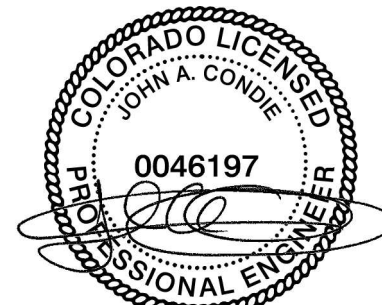

6.16.2026

Home Depot Store 1531
333 W. Allen St, Castle Rock, Colorado 80108

Site Lighting Replacement

REVISIONS

6/16/2026 PERMITS

Drawn By OFILECCIA
Designer OFILECCIA
Reviewer TKUHTZ
Manager TKUHTZ


Hard copy is intended to be 24"x36" when plotted. Scale(s) indicated and graphic quality may not be accurate for any other size.

PROJECT NO.
2600487

SHEET NO.

G-1
(SHEET 1 OF 3)

© Copyright 2024
All Rights Reserved

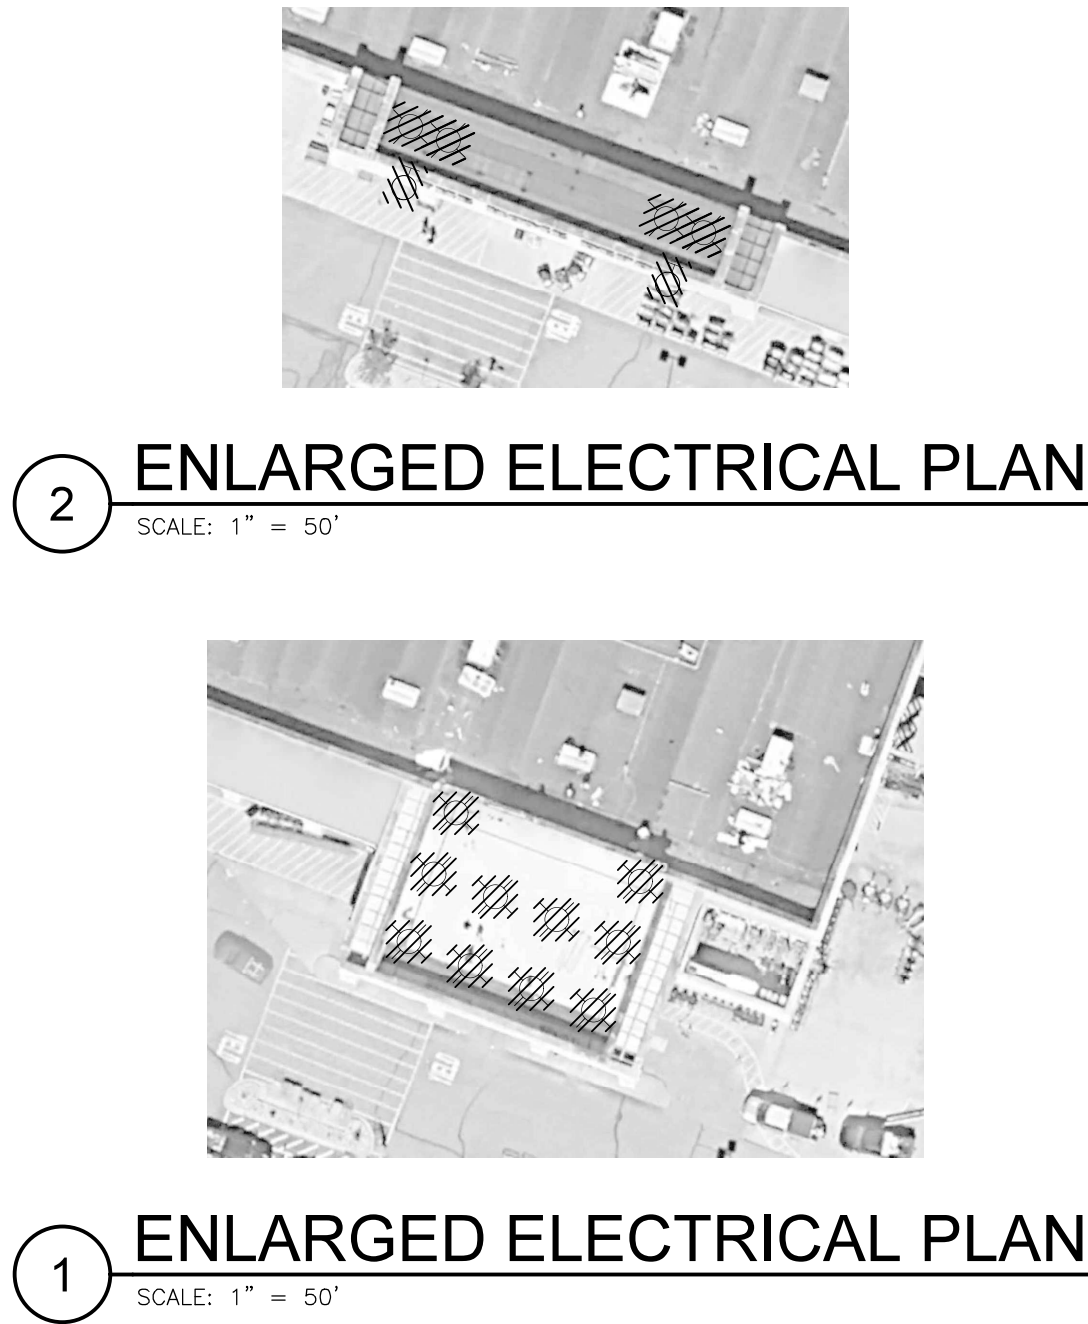

SYMBOL LEGEND

- EXISTING POLE MOUNTED FIXTURE LOCATION
- EXISTING BUILDING MOUNTED FIXTURE LOCATION
- EXISTING SURFACE MOUNTED FIXTURE LOCATION
- DEMOLITION HATCHING

DEMOLITION GENERAL NOTES

- EXISTING ELECTRICAL ITEMS INDICATED IN DRAWINGS ARE BASED ON OWNER'S LIMITED RECORD DRAWINGS AND ENGINEER'S LIMITED FIELD OBSERVATIONS. VISIT SITE TO UNDERSTAND COMPLETELY CONDITIONS UNDER WHICH WORK IS TO BE PERFORMED.
- FIELD VERIFY EXISTING CONDITIONS TO DETERMINE EXTENT OF WORK AND INCLUDE ALL COSTS ASSOCIATED WITH DEMOLITION IN BASE BID.
- CROSSHATCHING IDENTIFIES DEVICES/EQUIPMENT TO BE DISCONNECTED AND REMOVED.
- ELECTRICAL EQUIPMENT NOT SPECIFICALLY IDENTIFIED TO BE DISCONNECTED AND REMOVED IS TO BE MAINTAINED.
- REMOVE EXISTING FIXTURES AND INSTALL REPLACEMENT FIXTURES AT SAME LOCATION. ORIENT FIXTURES TO MATCH EXISTING AIMING, AS SHOWN ON PLAN.

DEMOLITION KEY NOTES

- EXISTING POLE AND POLE BASE SHALL REMAIN.

TOWN APPROVAL BLOCK

TOWN OF CASTLE ROCK APPROVAL
PLANS ARE HEREBY APPROVED FOR ONE YEAR FROM
DATE OF DEVELOPMENT SERVICES APPROVAL

APPROVED BY:

DEVELOPMENTAL SERVICES DATE

PROFESSIONAL ENGINEER'S CERTIFICATION

I HEREBY AFFIRM THAT THESE FINAL CONSTRUCTION PLANS WERE PREPARED UNDER MY DIRECT SUPERVISION, IN ACCORDANCE WITH ALL APPLICABLE TOWN OF CASTLE ROCK AND STATE OF COLORADO STANDARDS AND STATUTES, RESPECTIVELY; AND THAT I AM FULLY RESPONSIBLE FOR ALL DESIGN AND REVISIONS RELATIVE TO SAID PLANS.

ENGINEER SIGNATURE DATE



6.16.2026

REVISIONS

6/16/2026	PERMITS
Drawn By	OFILECCIA
Designer	OFILECCIA
Reviewer	TKUHTZ
Manager	TKUHTZ

Hard copy is intended to be 24"x36" when plotted. Scale(s) indicated and graphic quality may not be accurate for any other size.

PROJECT NO.

2600487

SHEET NO.

D-1

(SHEET 2 OF 3)


© Copyright 2024
All Rights Reserved

Home Depot Store 1531
333 W. Allen St, Castle Rock, Colorado 80108


Site Lighting Replacement

CASTLE ROCK TOWNSHIP ORDINANCE REQUIREMENTS		
REQUIREMENT	ORDINANCE	DESIGN
PARKING LOTS (INCLUDING MULTI-FAMILY), AND OUTDOOR STORAGE AREAS ADJACENT TO RESIDENTIAL ZONED LAND	MAXIMUM OF 5 FC	5 FC
WALKWAY AND GENERAL SITE LIGHTING	MAXIMUM OF 5 FC	5 FC
BUILDING MOUNTED LIGHTING	MAXIMUM OF 5 FC	5 FC
RETAIL OR POINT OF SERVICE CANOPIES (GAS STATIONS, DRIVE-UP WINDOWS, BANK DRIVE-UP LANES AND ATM)	MAXIMUM OF 20 FC	20 FC


CALCULATION SUMMARY					
LABEL	AVERAGE	MAX	MIN	AVG/MIN	MAX/MIN
10' X 10' GRID	0.95 FC	20.0 FC	0 FC	N/A FC	N/A FC
CANOPIES	12.21 FC	20.0 FC	1.0 FC	12.21 FC	20 FC
CIRCULATION AREAS	1.62 FC	5.0 FC	0 FC	N/A FC	N/A FC
PARKING	1.61 FC	4.0 FC	0.1 FC	16.1 FC	40 FC
PEDESTRIAN AREAS	1.69 FC	4.5 FC	0.4 FC	4.23 FC	11.25 FC
PROPERTY LINE	0.32 FC	2.0 FC	0 FC	N/A FC	N/A FC

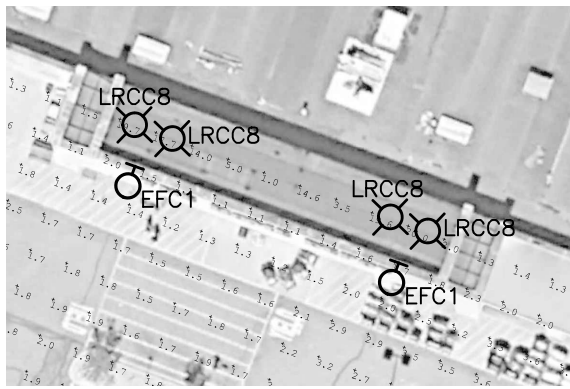


2 ENLARGED ELECTRICAL PLAN
 SCALE: 1" = 50'

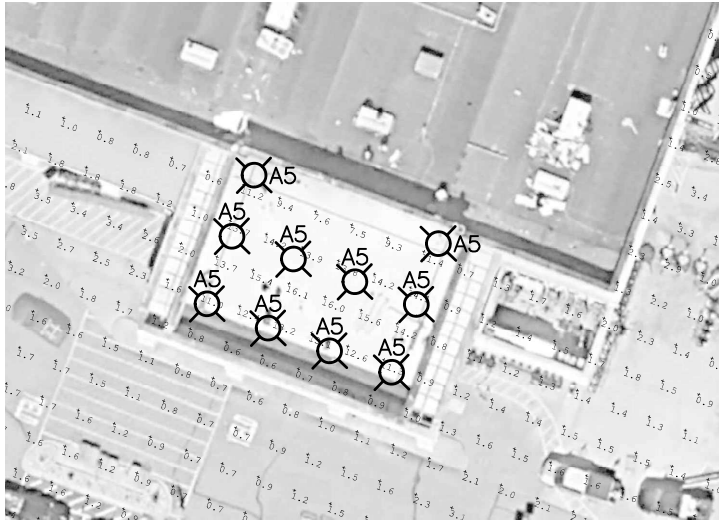

1 ENLARGED ELECTRICAL PLAN
 SCALE: 1" = 50'

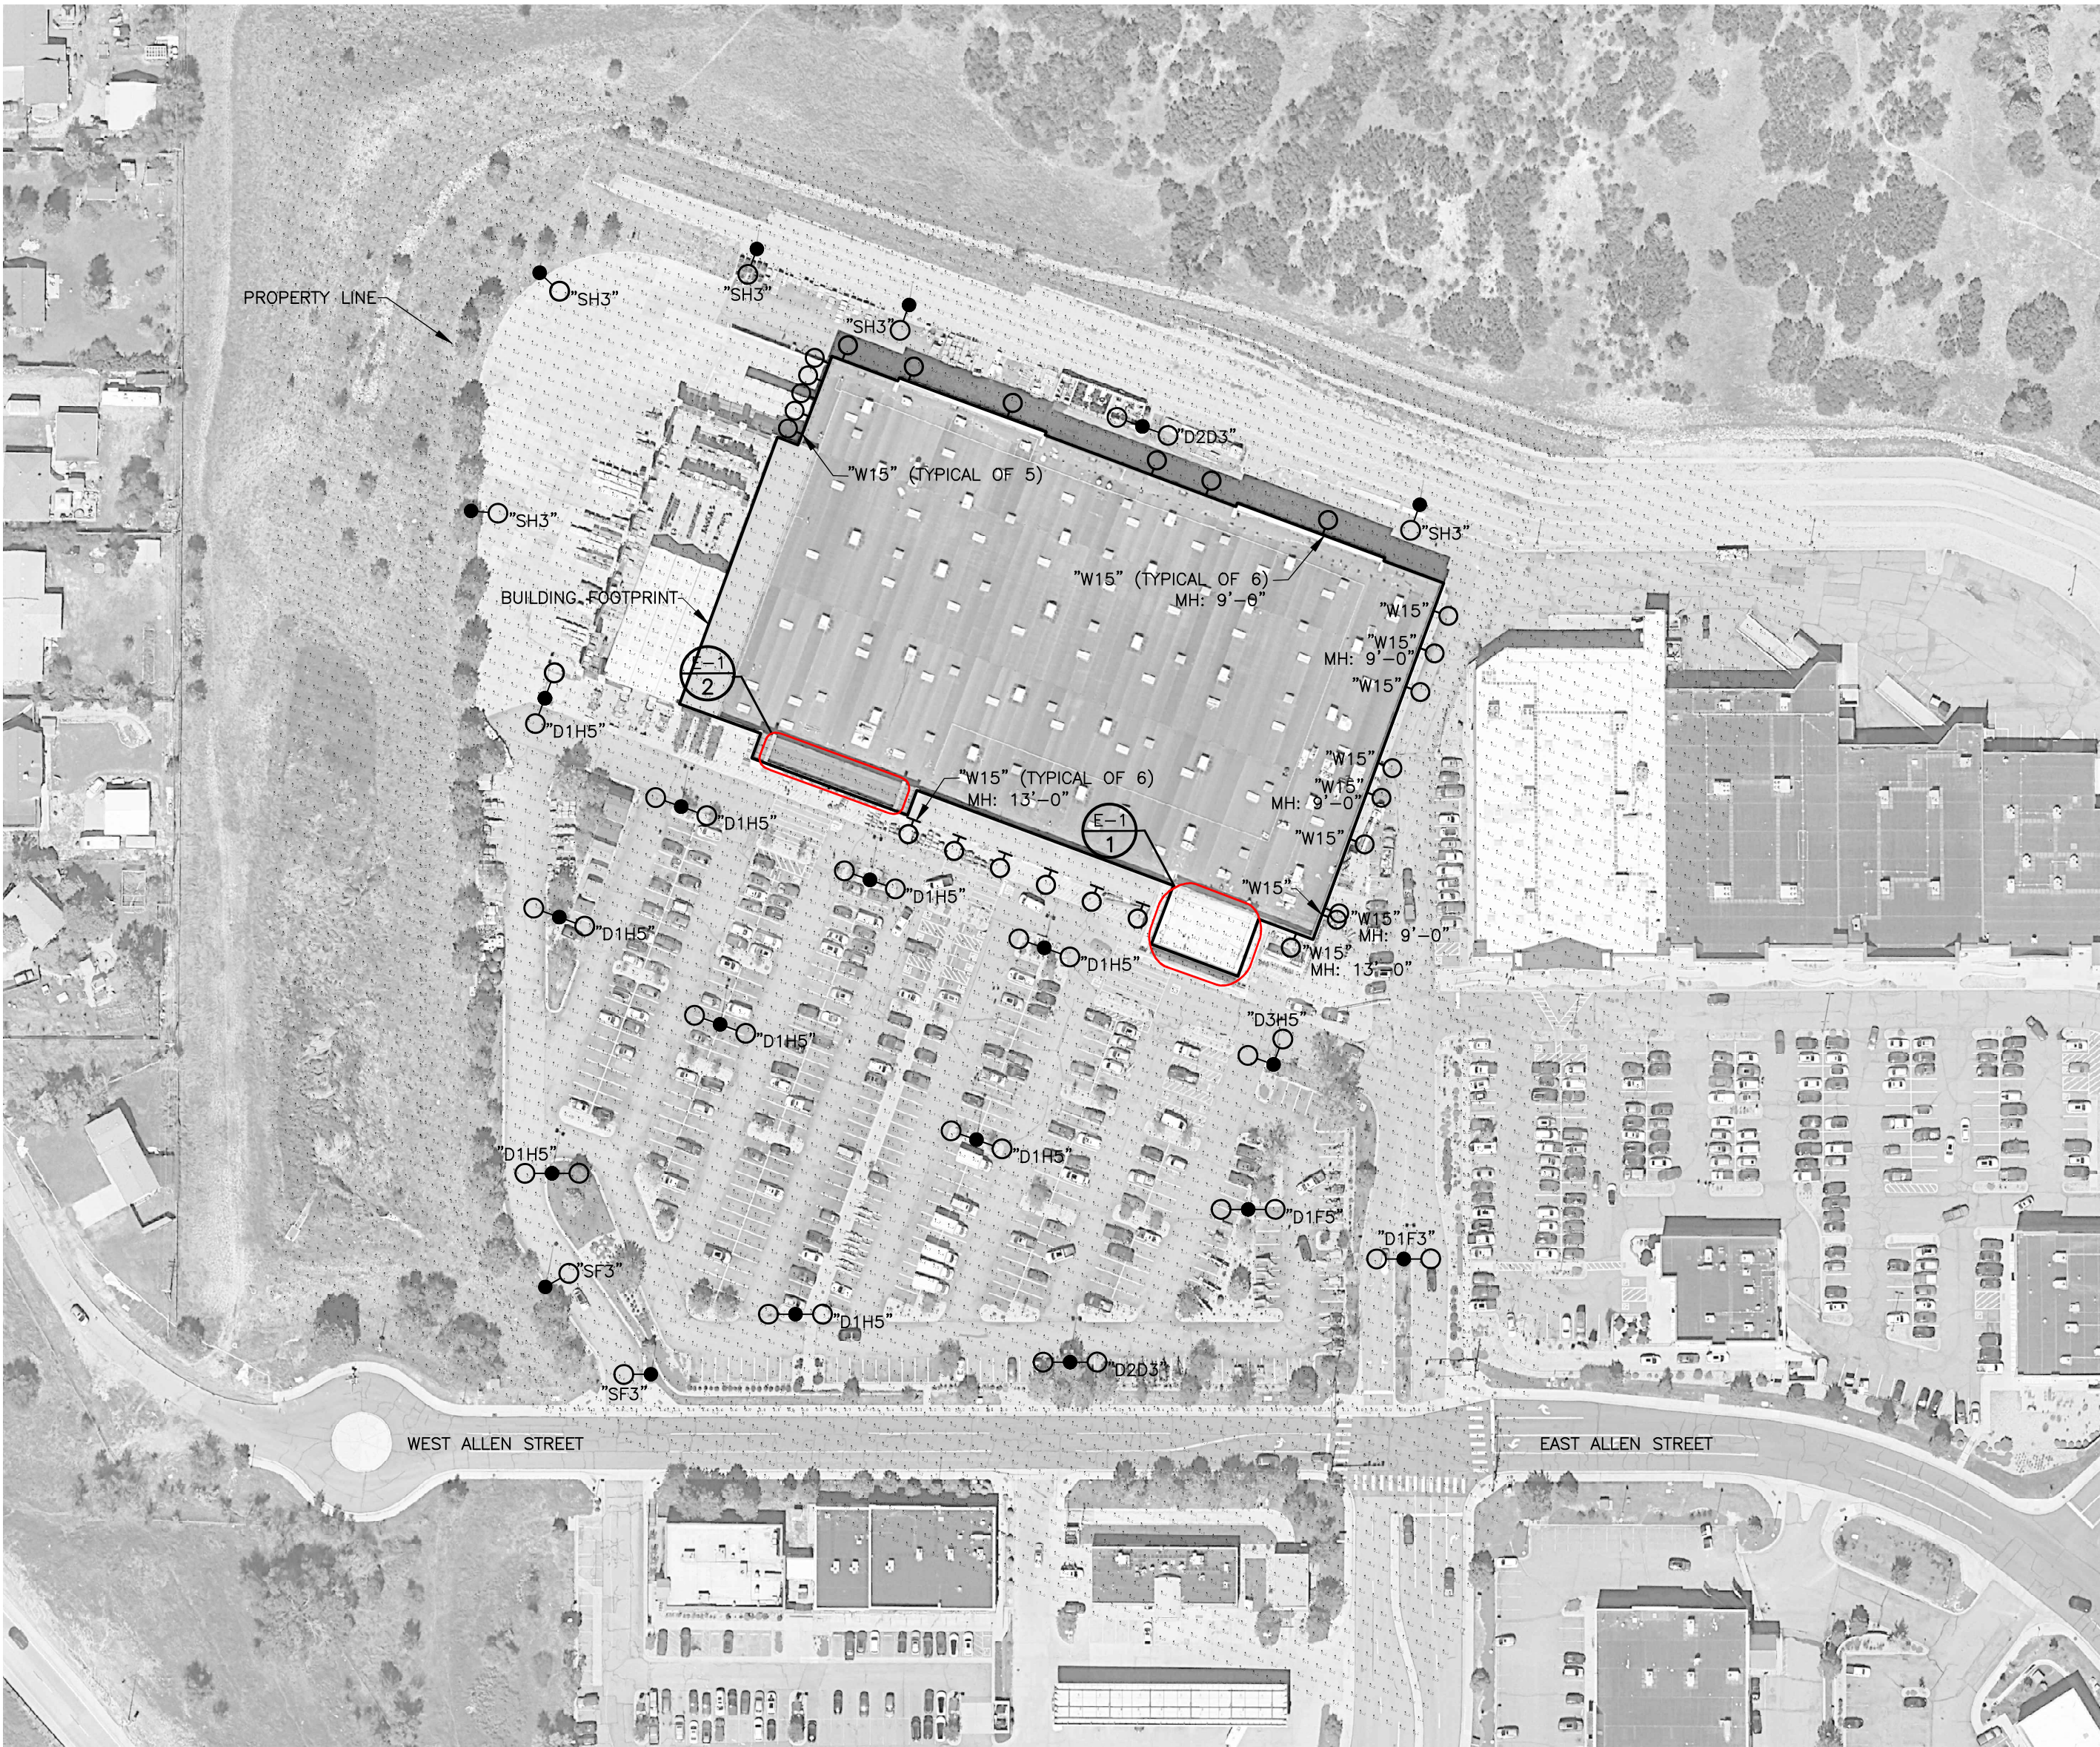

SITE ELECTRICAL PLAN

 

SYMBOL LEGEND

- NEW POLE MOUNTED FIXTURE LOCATION
- NEW BUILDING MOUNTED FIXTURE LOCATION
- ⊠ NEW SURFACE MOUNTED FIXTURE LOCATION

GENERAL NOTES

- CONTRACTOR SHALL OBTAIN PERMITS AS REQUIRED FROM LOCAL AUTHORITY HAVING JURISDICTION.
- ELECTRICAL DIAGRAMS ARE DIAGRAMMATIC AND REPRESENT THE ELECTRICAL DESIGN INTENT. PROVIDE WORK AND MATERIALS THAT FULLY MEET THE ELECTRICAL DESIGN INTENT. ELECTRICAL WORK SHALL CONFORM TO THE LATEST EDITION OF THE NATIONAL ELECTRICAL CODE (NEC) AS ADOPTED BY THE AUTHORITY HAVING JURISDICTION.
- EXISTING ELECTRICAL ITEMS INDICATED IN THE DRAWINGS ARE BASED ON THE OWNER'S LIMITED RECORD DRAWINGS AND ENGINEER'S LIMITED FIELD OBSERVATIONS. CONTRACTOR AND ALL APPLICABLE SUB-CONTRACTORS TO VISIT THE SITE TO UNDERSTAND COMPLETELY THE CONDITIONS UNDER WHICH THE WORK IS TO BE PERFORMED.
- FIELD VERIFY EXISTING CONDITIONS, NOTIFY OWNER/ENGINEER IF FIELD CONDITIONS DIFFER FROM PLAN.
- ALL EXISTING LIGHTING CONTROLS AND FEEDER CIRCUIT BREAKERS SHALL REMAIN UNCHANGED. AS INDICATED ON RECORD DRAWINGS, SEVENTY PERCENT OF THE PARKING LOT LIGHTING SHALL BE TURNED OFF 1.5 HOURS AFTER CLOSING, WITH THE EXCEPTION OF SECURITY LIGHTS PLACED ON THE BUILDING. IN THE CASE OF TWENTY-FOUR HOUR OPERATION, PERIMETER LIGHTING WILL BE TURNED OFF BY 11:30 PM.
- EXISTING LUMINAIRES SHALL BE REMOVED AND REPLACED AS INDICATED ON THE ELECTRICAL DEMOLITION PLAN.
- CONTRACTOR SHALL VERIFY CIRCUITS AND CONTROL OPERATION BEFORE AND AFTER WORK IS COMPLETE. THE CONTRACTOR MUST DEMONSTRATE COMPLETE OPERATION OF SITE LIGHTING AT SUBSTANTIAL COMPLETION.
- CONTRACTOR IS RESPONSIBLE FOR ALL MOUNTING ACCESSORIES NECESSARY FOR COMPLETE INSTALLATION OF NEW LUMINAIRES TO EXISTING POLES TO REMAIN.

LUMINAIRE SCHEDULE											
MARK	QTY	DESCRIPTION	MANUFACTURER	CATALOG NO.	LUMINAIRE DATA						REMARKS
					VOLTAGE	LOAD	LUMENS	CCT	CRI	LLF	
A5	10	DARK BRONZE LED CANOPY LIGHT, SURFACE MOUNTED, 5,400 LUMENS	CURRENT	ECLS-01-0-A5-SM-7-50-1-1-SM-DKBZ	277	39 VA	5,400 lm	5000K	70	1.000	MOUNT FIXTURE AT 18'-0" AFG.
D1F3	1	(2) DARK BRONZE TYPE III, 192W, 5000K TENON POLE MOUNTED LED MOUNTED AT 180 DEGREES	CURRENT	(2)EALS-04-E-F3-AW-7-50-D1-DKBZ	480	192 VA	31,500 lm	5000K	70	1.000	MOUNT FIXTURE AT 30'-0" AFG.
D1F5	1	(2) DARK BRONZE TYPE V, 182W, 5000K TENON POLE MOUNTED LED MOUNTED AT 180 DEGREES	CURRENT	(2)EALS-04-E-F5-SM-7-50-D1-DKBZ	480	182 VA	30,898 lm	5000K	70	1.000	MOUNT FIXTURE AT 30'-0" AFG.
D1H5	9	(2) DARK BRONZE TYPE V, 246W, 5000K TENON POLE MOUNTED LED MOUNTED AT 180 DEGREES	CURRENT	(2)EALS-04-E-H5-SH-7-50-D1-DKBZ	480	246 VA	40,000 lm	5000K	70	1.000	MOUNT FIXTURE AT 30'-0" AFG.
D2D3	2	(2) DARK BRONZE TYPE III, 126W, 5000K TENON POLE MOUNTED LED MOUNTED AT 180 DEGREES	CURRENT	(2)EALS-04-E-D3-AW-7-50-D1-DKBZ	480	126 VA	21,000 lm	5000K	70	1.000	MOUNT FIXTURE AT 30'-0" AFG.
D3H5	1	(2) DARK BRONZE TYPE V, 246W, 5000K TENON POLE MOUNTED LED MOUNTED AT 90 DEGREES	CURRENT	(2)EALS-04-E-H5-SH-7-50-D1-DKBZ	480	246 VA	40,000 lm	5000K	70	1.000	MOUNT FIXTURE AT 30'-0" AFG.
EFC1	2	DARK BRONZE LED FLOODLIGHT, 4,000 LUMENS	CURRENT	EFC1-01-0-04-33-7-50-N-A-V1-DKBZ	480	30 VA	4,000 lm	5000K	70	1.000	MOUNT FIXTURE AT 15'-0" AFG.
LRC08	4	DARK BRONZE LED 8" RECESSED DOWNLIGHT, 2,964 LUMENS	CURRENT	LRC-C-08R-0-30-WD-SD-CL-MR-T-50	480	27.9 VA	2,964 lm	5000K	90	1.000	MOUNT FIXTURE AT 13'-0" AFG.
SF3	2	DARK BRONZE TYPE III, 96W, 5000K TENON POLE MOUNTED LED	CURRENT	EALS-04-E-F3-AW-7-50-D1-DKBZ	480	96 VA	15,750 lm	5000K	70	1.000	MOUNT FIXTURE AT 30'-0" AFG.
SH3	5	DARK BRONZE TYPE III, 123W, 5000K TENON POLE MOUNTED LED	CURRENT	EALS-04-E-H3-AW-7-50-D1-DKBZ	480	123 VA	21,001 lm	5000K	70	1.000	MOUNT FIXTURE AT 30'-0" AFG.
W15	26	DARK BRONZE TYPE III, 14W, 5000K WALL MOUNTED LED	CURRENT	VPW-1-24L-15-5K7-3-277-DBT	480	14 VA	1,759 lm	5000K	70	1.000	MOUNT FIXTURE AT 15'-0" AFG., UNO.
UNO = UNLESS NOTED OTHERWISE											

TOWN APPROVAL BLOCK

TOWN OF CASTLE ROCK APPROVAL
 PLANS ARE HEREBY APPROVED FOR ONE YEAR FROM
 DATE OF DEVELOPMENT SERVICES APPROVAL

APPROVED BY:

DEVELOPMENTAL SERVICES DATE

PROFESSIONAL ENGINEER'S CERTIFICATION

I HEREBY AFFIRM THAT THESE FINAL CONSTRUCTION PLANS WERE PREPARED UNDER MY DIRECT SUPERVISION, IN ACCORDANCE WITH ALL APPLICABLE TOWN OF CASTLE ROCK AND STATE OF COLORADO STANDARDS AND STATUTES, RESPECTIVELY; AND THAT I AM FULLY RESPONSIBLE FOR ALL DESIGN AND REVISIONS RELATIVE TO SAID PLANS.

ENGINEER SIGNATURE DATE



6.16.2026

REVISIONS

6/16/2026 PERMITS

Drawn By OFILECCIA
 Designer OFILECCIA
 Reviewer TKUHTZ
 Manager TKUHTZ

Hard copy is intended to be 24"x36" when plotted. Scale(s) indicated and graphic quality may not be accurate for any other size.

PROJECT NO.

2600487

SHEET NO.


E-1

(SHEET 3 OF 3)

©Copyright 2024 All Rights Reserved

Scale: 1 inch= 50 Ft.

THIS IS A D SIZE SHEET. THE NOTED SCALE IS NOT VALID IF PRINTED AS ANY OTHER SIZE.

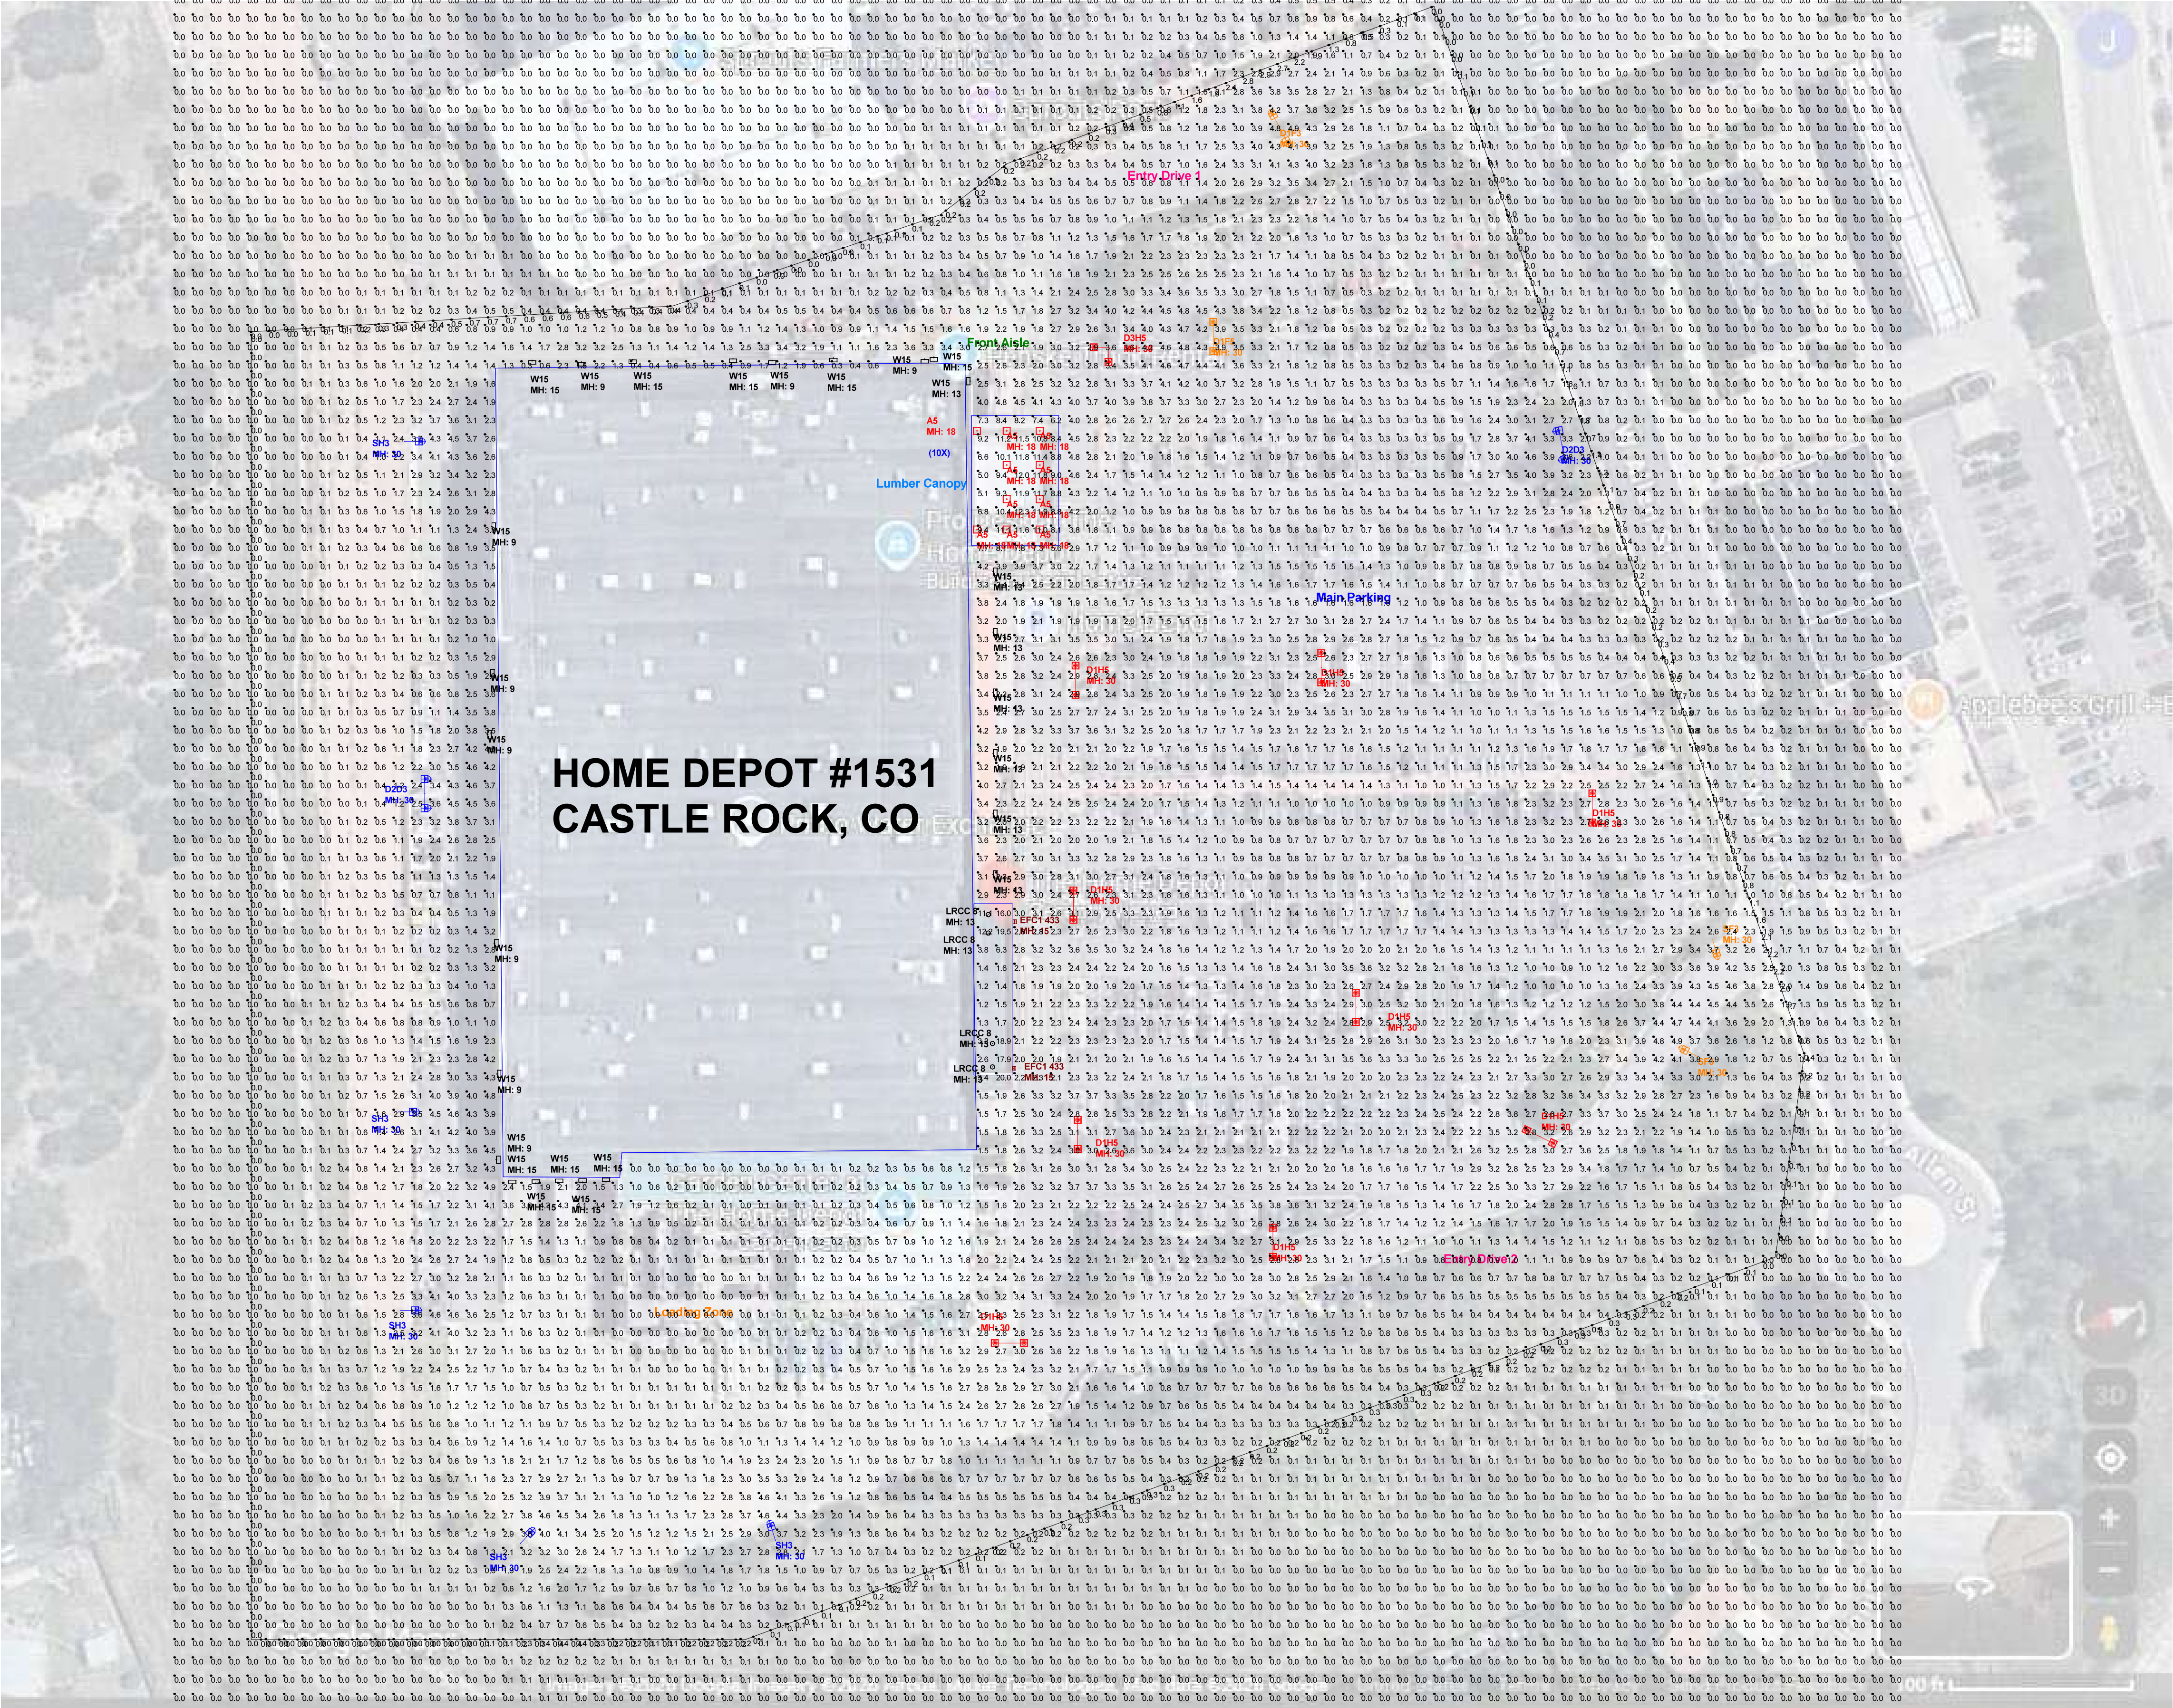

The magnitude of the differences between double and single methods and field measurements varies. In general, differences of less than 20% can be expected, but in extreme cases, where a calculation method cannot handle the complexity of the lighting system, they may be greater. A more complete discussion of the uncertainties is available.

ANSI E83.1-2002
Lighting Software: Calculation of Light and its Effects

Provided for:
Kathleen Smith
CURRENT

Provided By:
Application Solution Center
apps@currentlighting.com

 
 
 
6085 Parkland Blvd,
Mayfield Heights, OH 44124

Designer: Joshua Watkins

Date: 5/4/2026

Drawing #: A260297C-The Home Depot #1531 Castle Rock, CO (city)/AGI

Home Depot Site #1531
333 W Allen St, Castle Rock, CO 80108
EVLVE LED AREA LIGHT
Mounting Heights (MH) as shown
Horizontal fcs at grade
Values at Initial Output

Luminaire Schedule							
Symbol	Qty	Label	Arrangement	LLF	Description	Arr. Watts	Arr. Lum. Lumens
	10	A5	SINGLE	0.855	ECLS01_A5SM750_____	39	5400
	1	D1F3	BACK-BACK	1.000	EALS04_F3AW750_____	192	31500
	9	D1H5	D180	1.000	EALS04_H5SH750_____	246	40000
	2	D2D3	ROTATED OPTICS	1.000	EALS04_D3AW750____S1 & EALS04_D3AW750____S2	126	21000
	1	D3H5	2 @ 90 DEGREES_1	1.000	EALS04_H5SH750_____	246	40000
	2	EFC1 433	SINGLE	1.000	EFC101_0433750_____	30	4000
	4	LRCC 8	SINGLE	1.000	LRCC08R030XXXX	27.9	2964
	2	SF3	SINGLE	1.000	EALS04_F3AW750_____	96	15750
	5	SH3	SINGLE	1.000	EALS04_H3AW750_____	123	21001
	26	W15	SINGLE	1.000	VPW1-24L-15-5K7-3	14	1759
	1	D1F5	BACK-BACK	0.873	EALS04_F5SM750_____	182	30898

Calculation Summary							
Label	CalcType	Units	Avg	Max	Min	Avg/Min	Max/Min
10'x10' Grid	Illuminance	Fc	0.87	20.0	0.0	N.A.	N.A.
Property Line	Illuminance	Fc	0.32	2.9	0.0	N.A.	N.A.



The magnitude of the differences between double method methods and field measurements varies. In general, differences of less than 20% can be expected, but in extreme cases, where a calculation method cannot handle the complexity of the lighting system, they may be greater. A more complete discussion of the uncertainties is available.

ANSI E83.1-84-90
Lighting Science: Calculation of Light and its Effects

Provided for:
Kathleen Smith
CURRENT

Provided BY:
Application Solution Center
apps@currentlighting.com

6085 Parkland Blvd,
Mayfield Heights, OH 44124

Designer: Joshua Watkins

Date: 5/4/2026

Drawing #: A260297C-The Home Depot #1531 Castle Rock, CO (city)/AGI

Home Depot Site #1531
333 W Allen St, Castle Rock, CO 80108
EVOLVE LED AREA LIGHT
Mounting Heights (MH) as shown
Horizontal fcs at grade
Values at Initial Output

[illegible][illegible]

Lumination
DECAUX MAX Series
 Remodal and New Construction

CUSTOMER NAME _____
 Project Name _____ Type _____
 Catalog Number _____

LRC		C	R													
MODEL	AVAILABLE FINISHES	FINISH	TYPE	LENGTH (mm)	WIDTH (mm)	DISTRIBUTION	REFLECTOR COATING	REFLECTOR COLOR	PLAQUE COLOR	CEC	DATA & CERTIFICATIONS	OPTIONS*				
MAX-1	C = Natural Aluminum R = Anodized Aluminum Commercial Aluminum	MAX-1 Natural MAX-1 R MAX-1 Commercial	120° - 270°	15.5 15.5 15.5	113 113 113	NO NO NO	NO NO NO	15° 15° 15°	MAX-1 MAX-1 MAX-1	8° 15° 15°	27° 30° 30°	15° - 27° 30° 30°	Options = None			
MAX-2		MAX-2 Natural MAX-2 R MAX-2 Commercial	120° - 270°	15.5 15.5 15.5	113 113 113	NO NO NO	NO NO NO	15° 15° 15°	MAX-2 MAX-2 MAX-2	8° 15° 15°	27° 30° 30°	15° - 27° 30° 30°	Options = None			
MAX-3		MAX-3 Natural MAX-3 R MAX-3 Commercial	120° - 270°	15.5 15.5 15.5	113 113 113	NO NO NO	NO NO NO	15° 15° 15°	MAX-3 MAX-3 MAX-3	8° 15° 15°	27° 30° 30°	15° - 27° 30° 30°	Options = None			
MAX-4		MAX-4 Natural MAX-4 R MAX-4 Commercial	120° - 270°	15.5 15.5 15.5	113 113 113	NO NO NO	NO NO NO	15° 15° 15°	MAX-4 MAX-4 MAX-4	8° 15° 15°	27° 30° 30°	15° - 27° 30° 30°	Options = None			
MAX-5		MAX-5 Natural MAX-5 R MAX-5 Commercial	120° - 270°	15.5 15.5 15.5	113 113 113	NO NO NO	NO NO NO	15° 15° 15°	MAX-5 MAX-5 MAX-5	8° 15° 15°	27° 30° 30°	15° - 27° 30° 30°	Options = None			
MAX-6		MAX-6 Natural MAX-6 R MAX-6 Commercial	120° - 270°	15.5 15.5 15.5	113 113 113	NO NO NO	NO NO NO	15° 15° 15°	MAX-6 MAX-6 MAX-6	8° 15° 15°	27° 30° 30°	15° - 27° 30° 30°	Options = None			
MAX-7		MAX-7 Natural MAX-7 R MAX-7 Commercial	120° - 270°	15.5 15.5 15.5	113 113 113	NO NO NO	NO NO NO	15° 15° 15°	MAX-7 MAX-7 MAX-7	8° 15° 15°	27° 30° 30°	15° - 27° 30° 30°	Options = None			
MAX-8		MAX-8 Natural MAX-8 R MAX-8 Commercial	120° - 270°	15.5 15.5 15.5	113 113 113	NO NO NO	NO NO NO	15° 15° 15°	MAX-8 MAX-8 MAX-8	8° 15° 15°	27° 30° 30°	15° - 27° 30° 30°	Options = None			
MAX-9		MAX-9 Natural MAX-9 R MAX-9 Commercial	120° - 270°	15.5 15.5 15.5	113 113 113	NO NO NO	NO NO NO	15° 15° 15°	MAX-9 MAX-9 MAX-9	8° 15° 15°	27° 30° 30°	15° - 27° 30° 30°	Options = None			
MAX-10		MAX-10 Natural MAX-10 R MAX-10 Commercial	120° - 270°	15.5 15.5 15.5	113 113 113	NO NO NO	NO NO NO	15° 15° 15°	MAX-10 MAX-10 MAX-10	8° 15° 15°	27° 30° 30°	15° - 27° 30° 30°	Options = None			
MAX-11		MAX-11 Natural MAX-11 R MAX-11 Commercial	120° - 270°	15.5 15.5 15.5	113 113 113	NO NO NO	NO NO NO	15° 15° 15°	MAX-11 MAX-11 MAX-11	8° 15° 15°	27° 30° 30°	15° - 27° 30° 30°	Options = None			
MAX-12		MAX-12 Natural MAX-12 R MAX-12 Commercial	120° - 270°	15.5 15.5 15.5	113 113 113	NO NO NO	NO NO NO	15° 15° 15°	MAX-12 MAX-12 MAX-12	8° 15° 15°	27° 30° 30°	15° - 27° 30° 30°	Options = None			
MAX-13		MAX-13 Natural MAX-13 R MAX-13 Commercial	120° - 270°	15.5 15.5 15.5	113 113 113	NO NO NO	NO NO NO	15° 15° 15°	MAX-13 MAX-13 MAX-13	8° 15° 15°	27° 30° 30°	15° - 27° 30° 30°	Options = None			
MAX-14		MAX-14 Natural MAX-14 R MAX-14 Commercial	120° - 270°	15.5 15.5 15.5	113 113 113	NO NO NO	NO NO NO	15° 15° 15°	MAX-14 MAX-14 MAX-14	8° 15° 15°	27° 30° 30°	15° - 27° 30° 30°	Options = None			
MAX-15		MAX-15 Natural MAX-15 R MAX-15 Commercial	120° - 270°	15.5 15.5 15.5	113 113 113	NO NO NO	NO NO NO	15° 15° 15°	MAX-15 MAX-15 MAX-15	8° 15° 15°	27° 30° 30°	15° - 27° 30° 30°	Options = None			
MAX-16		MAX-16 Natural MAX-16 R MAX-16 Commercial	120° - 270°	15.5 15.5 15.5	113 113 113	NO NO NO	NO NO NO	15° 15° 15°	MAX-16 MAX-16 MAX-1							

[illegible][illegible]