



ISSUE RECORD	
DATE	REV. DESCRIPTION
01/16/2024	ENTITLEMENT SET
10/08/2024	ENTITLEMENT SET

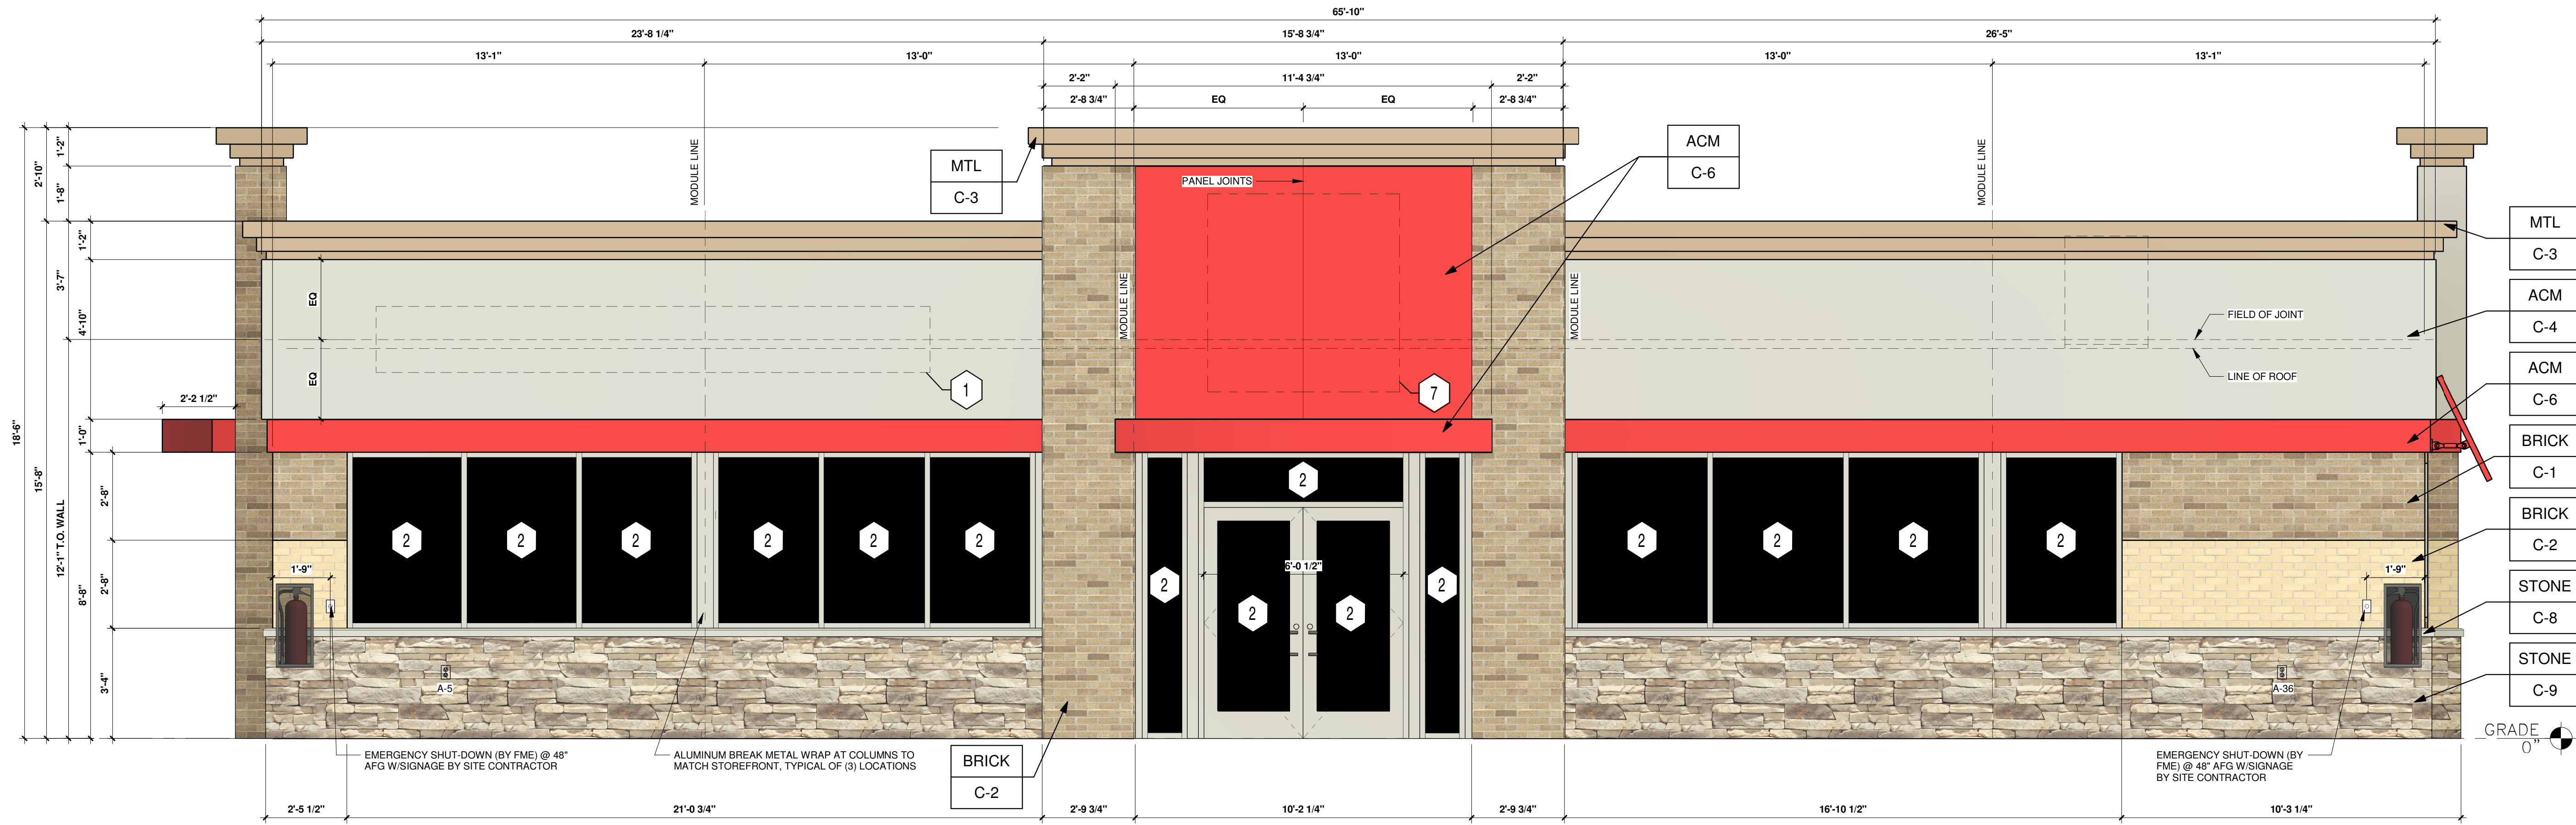

1 SOUTH-EAST ELEVATION
3/8" = 1'-0"

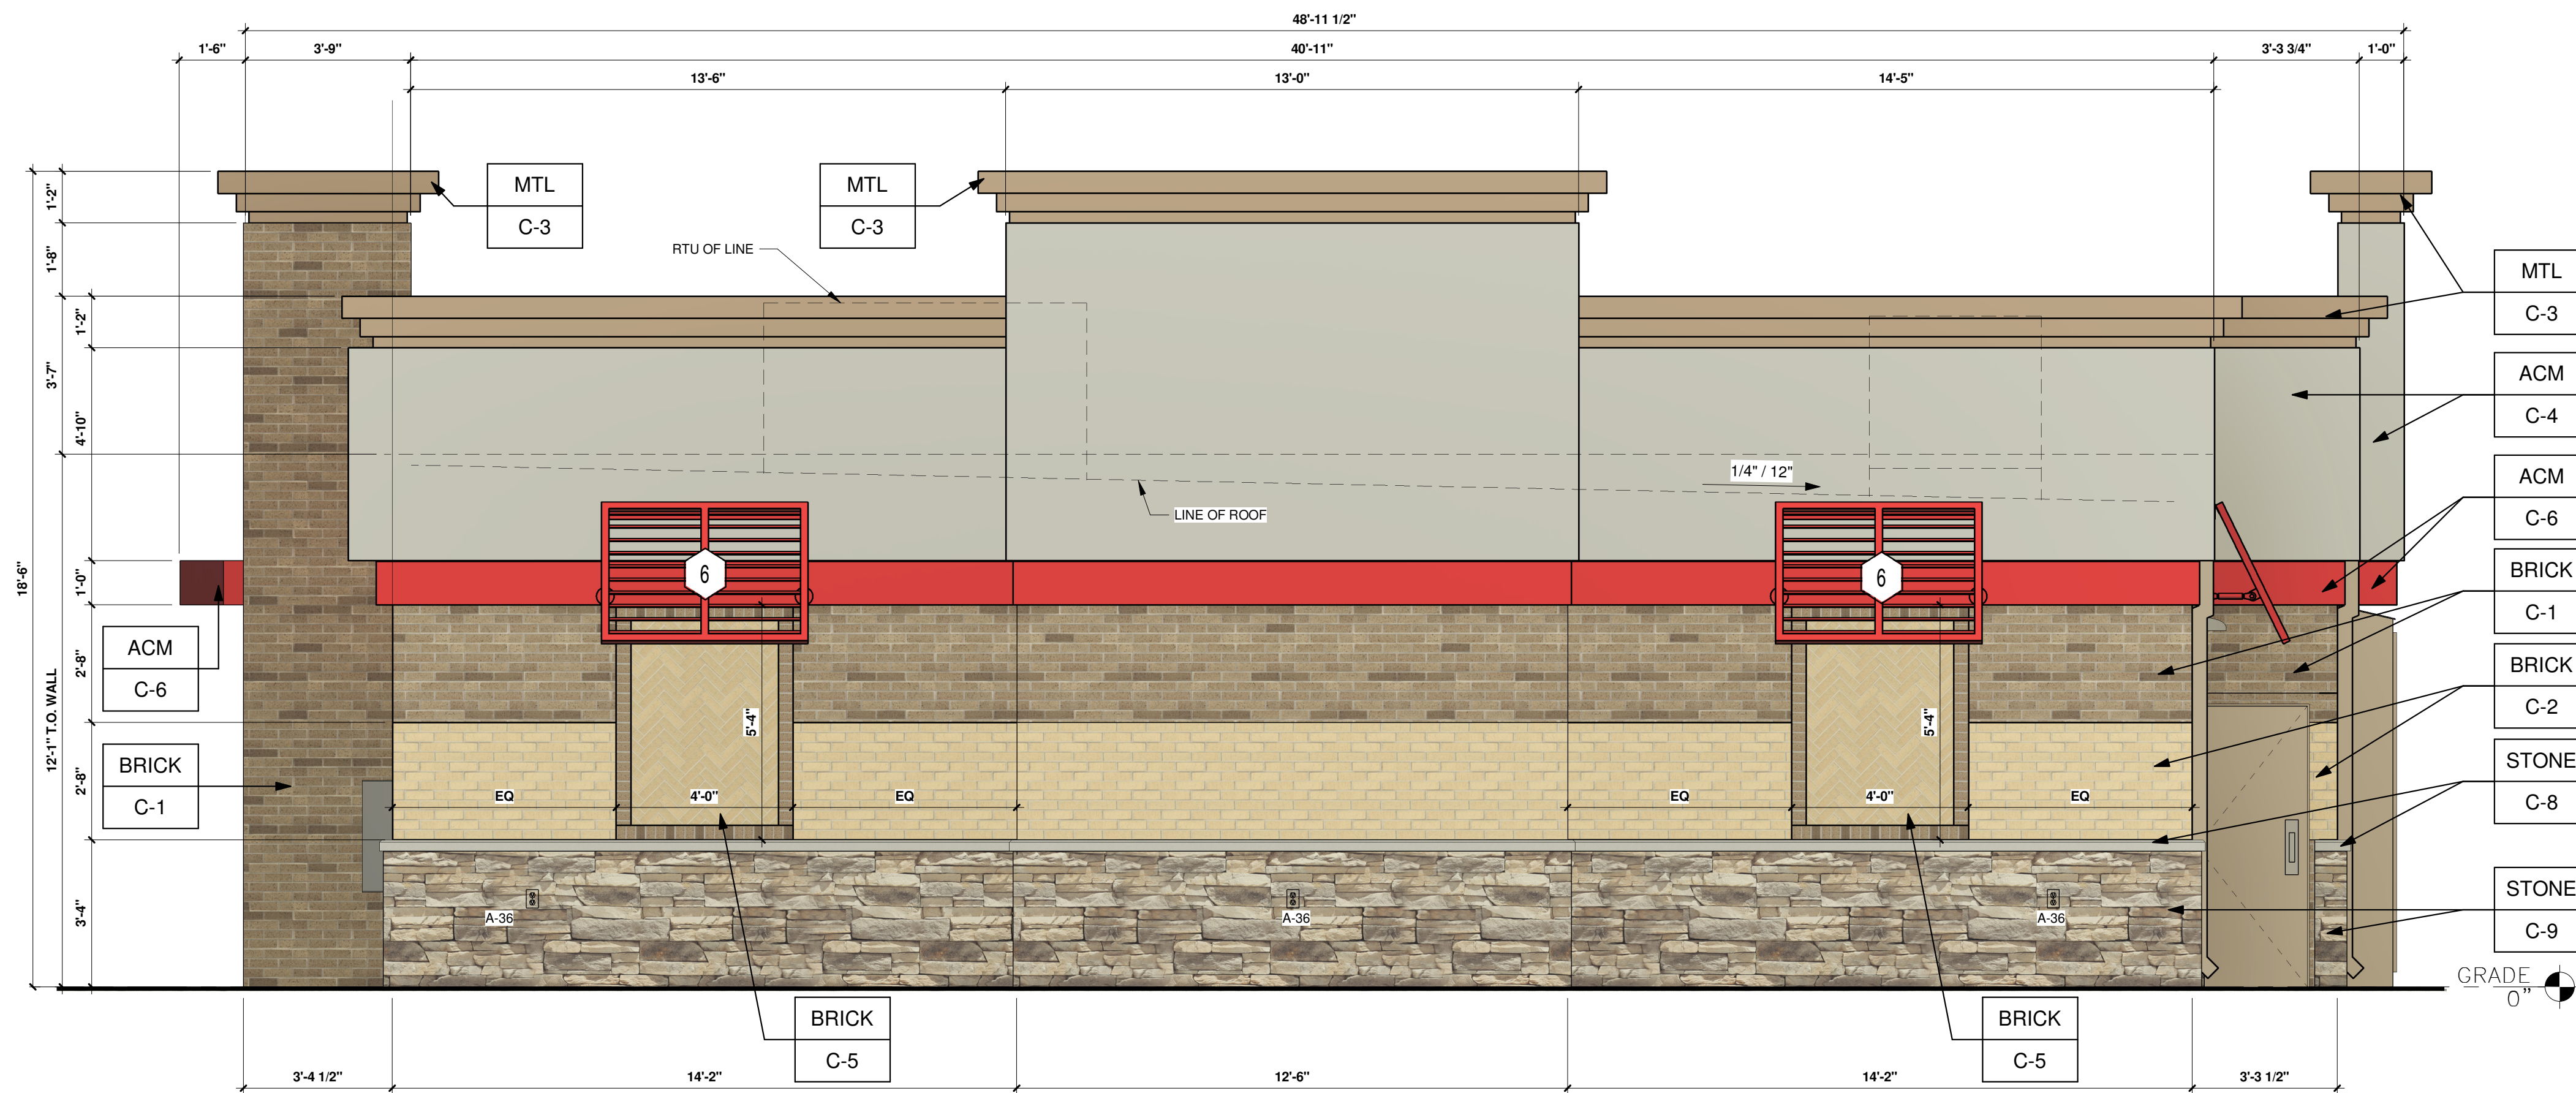

2 NORTH-EAST ELEVATION
3/8" = 1'-0"

KEYED NOTES:

- 1 ROUTED LETTER LOGO SIGNAGE BY FMS
- 2 CLEAR ANODIZED ALUMINUM STOREFRONT SYSTEM - KAWNEER, YKK OR EQUAL C-7
- 3 EXTERIOR LIGHTING, REFER TO LIGHTING PLAN SHEET EL2
- 4 4" x 4" PAINTED METAL DOWNSPOUTS C-3
- 5 DOORS (EXTERIOR SIDE) AND DOOR FRAMES PAINTED C-3
- 6 METAL AWNING BY B&C AWNING INC. OR EQUAL C-6
- 7 MURPHY STAR LOGO SIGNAGE BY SIGN CONTRACTOR

EXTERIOR FINISHES:

- ACM ACM (3MM THICKNESS) BY FMS
- BRICK THIN BRICK BY FMS
- MTL 20 GA. SHEET METAL (UNLESS NOTED OTHERWISE) BY FMS
- STONE STONE SILL BY FMS

EXTERIOR PAINT/COLORS:

- C-1 THIN BRICK VENEER - LIGHT SANDSTONE VELOUR BY ENDICOTT (WIRE CUT FINISH) WITH ENDURA MAX PREBLEND GREY COLOR GROUT BY FMS
- C-2 THIN BRICK VENEER - IVORY BLEND VELOUR BY ENDICOTT (WIRE CUT FINISH) WITH ENDURA MAX PREBLEND GREY COLOR GROUT BY FMS
- C-3 'DORMER BROWN' SW #7521 BY FMS
- C-4 REYNOBOND #4 NATURAL BRUSHED ALUMINUM BY ARCONIC BY FMS
- C-5 THIN BRICK VENEER HERRINGBONE PATTERN - 'IVORY BLEND VELOUR' BY ENDICOTT BY FMS
- C-6 'PROGRAM RED' BY ALPOLIC BY FMS
- C-7 CLEAR ANODIZED ALUMINUM STOREFRONT BY FMS
- C-8 STONE SILL - CONCRETE GRAY CAP BY FMS
- C-9 STONE VENEER - 'ALDERWOOD STACKED STONE' BY ELDORADO STONE BY FMS

PROFESSIONAL SEAL

PROFESSIONAL IN CHARGE
SCOTT LOIKITS
PROJECT MANAGER
JOSHUA MATOS
QUALITY CONTROL
CHRIS CERBO
DRAWN BY
ST

PROJECT NAME

MURPHY USA

MURPHY OIL CONVENIENCE STORE

FOUNDERS PKWY & METZLER WAY, CASTLE ROCK COLORADO 80108

FREY MOSS STRUCTURE

1801 Rockdale Industrial Blvd.
Conyers, Georgia 30012
Voice: (800) 366-6385
Fax: (770) 483-6037

FMS JOB NUMBER G23MU00000
FMS MODEL NUMBER XXXXXX

PROJECT NUMBER
20230962.5

SHEET TITLE


ARCHITECTURAL ELEVATIONS (BUILDING)

SHEET NUMBER


A-1 (08 OF 10)

PROTO V4.0 06/28/2024
2800 SQ. FT. BUILDING

ISSUE RECORD		
DATE	REV.	DESCRIPTION
01/16/2024		ENTITLEMENT SET
10/08/2024		ENTITLEMENT SET

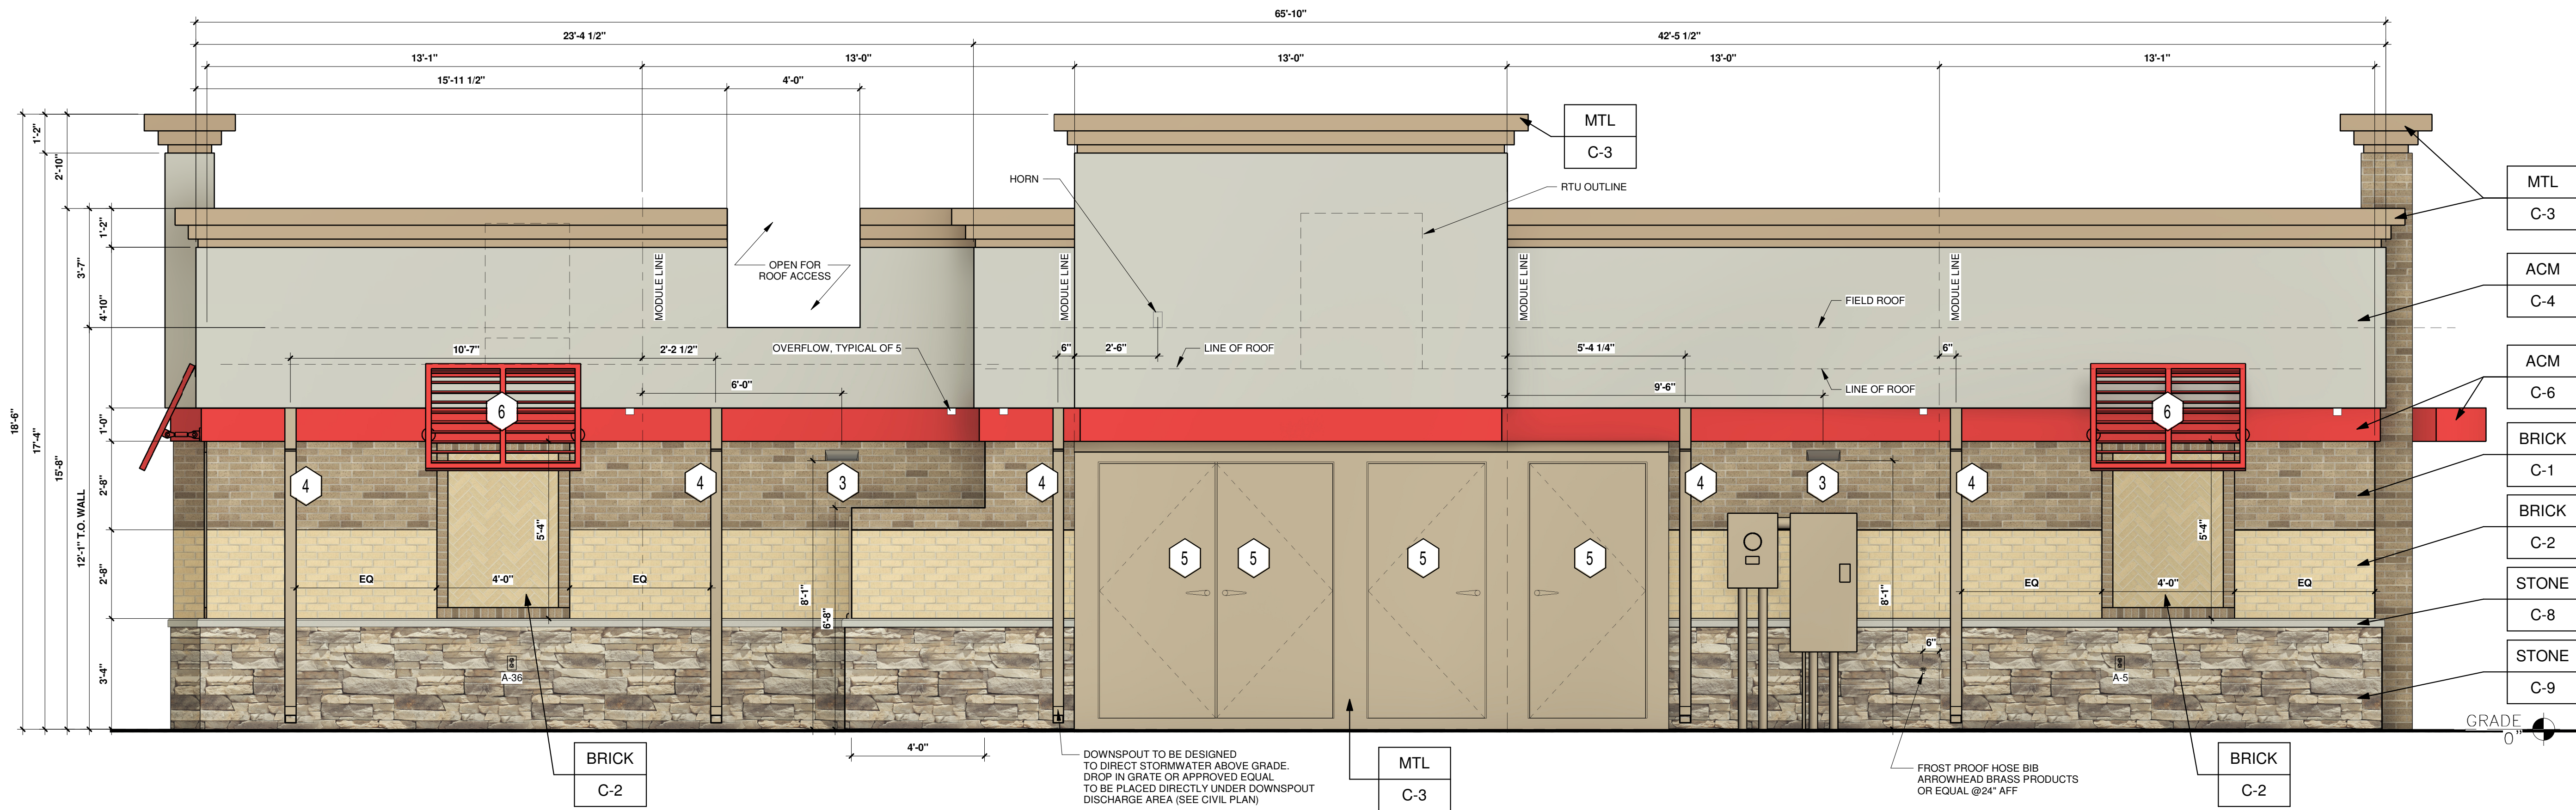

1 NORTH-WEST ELEVATION - METZLER WAY
3/8" = 1'-0"

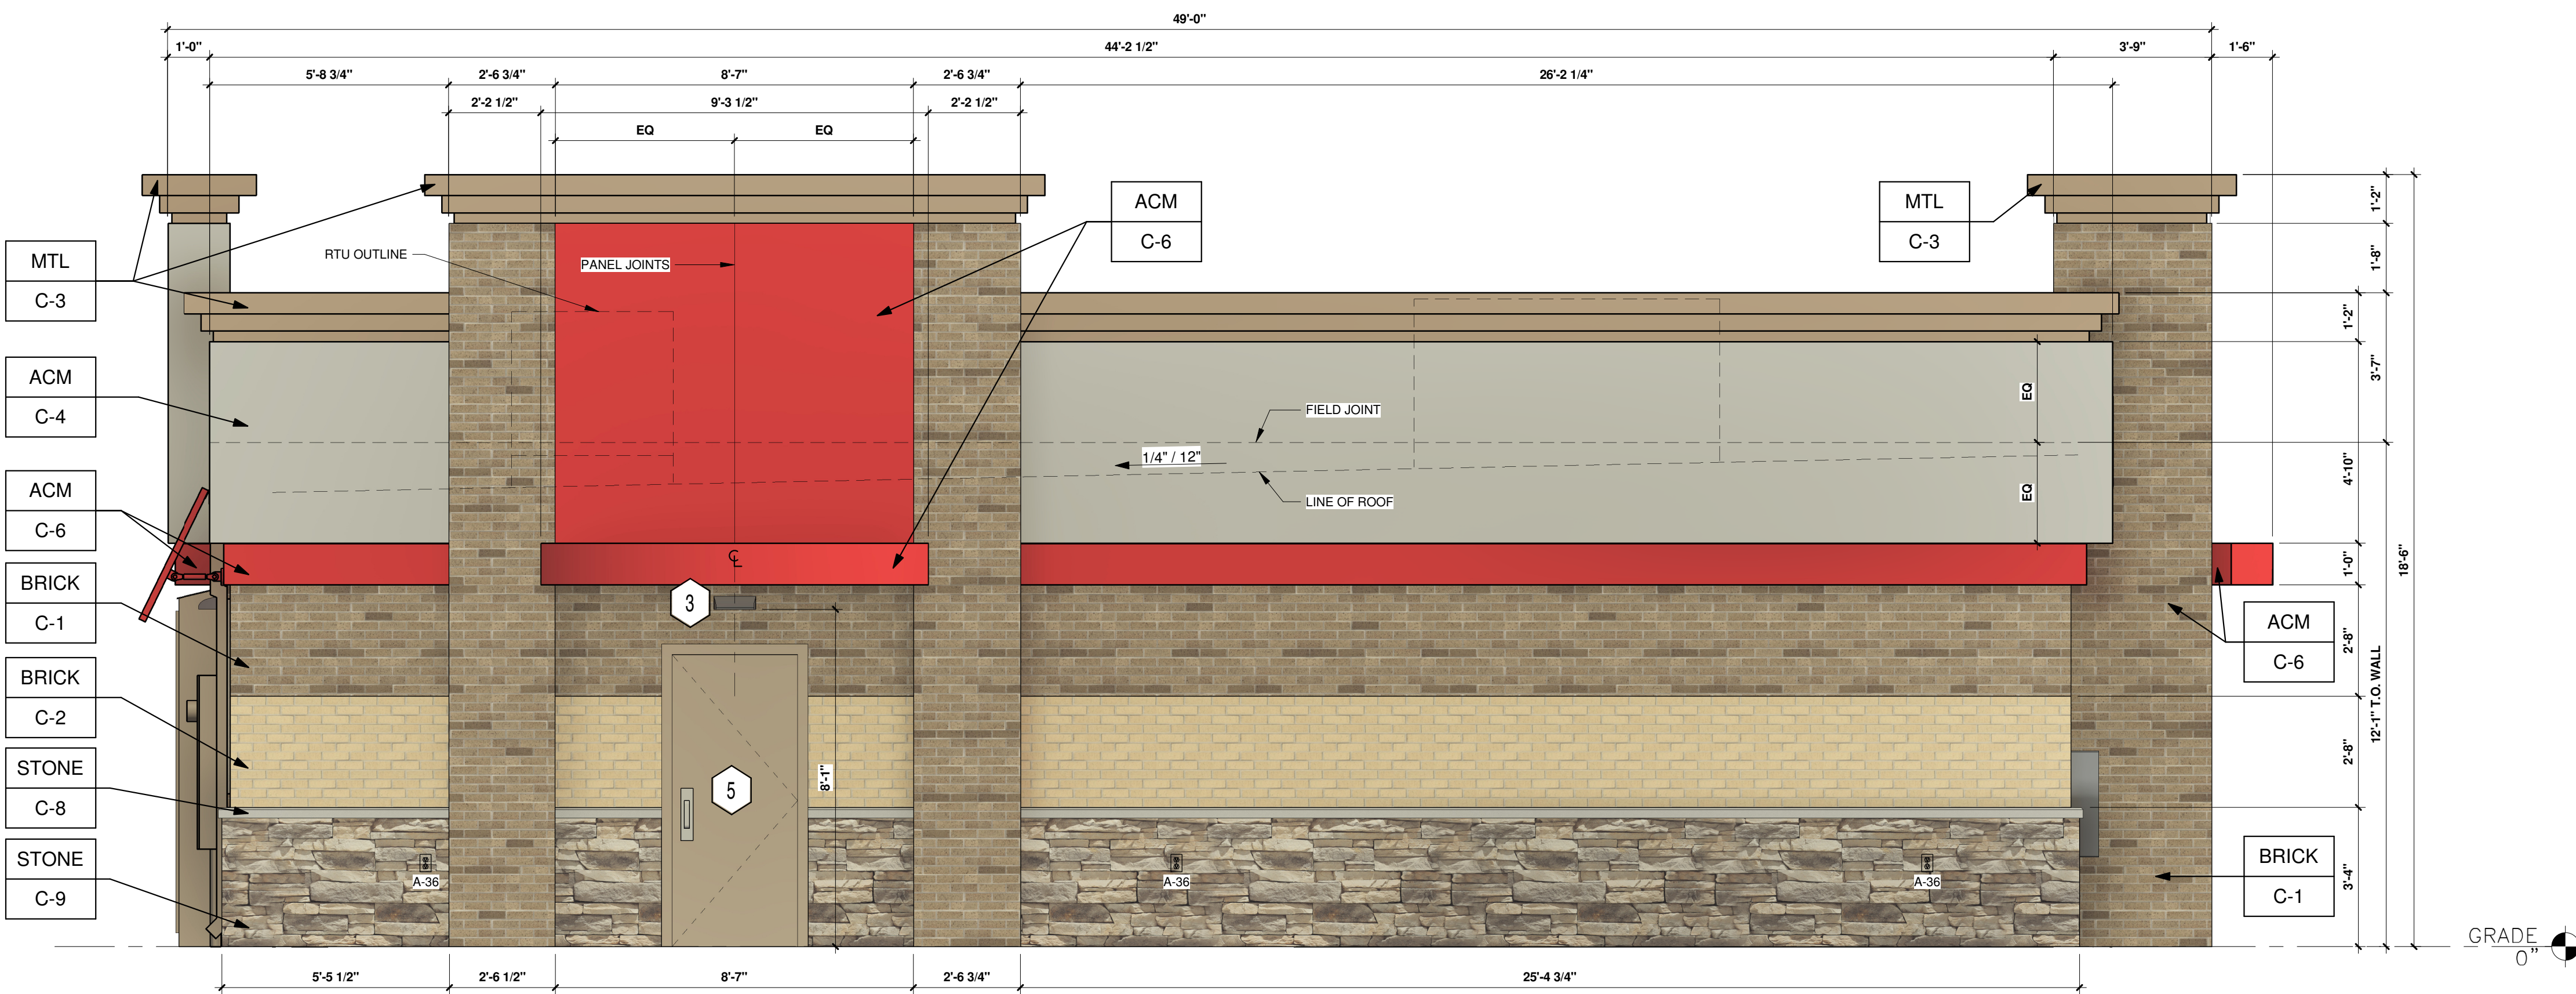

2 SOUTH-WEST ELEVATION - FOUNDERS PKWY
3/8" = 1'-0"

KEYED NOTES:

- 1 ROUTED LETTER LOGO SIGNAGE BY FMS
- 2 CLEAR ANODIZED ALUMINUM STOREFRONT SYSTEM - KAWNEER, YKK OR EQUAL C-7
- 3 EXTERIOR LIGHTING, REFER TO LIGHTING PLAN SHEET EL2
- 4 4" x 4" PAINTED METAL DOWNSPOUTS C-3
- 5 DOORS (EXTERIOR SIDE) AND DOOR FRAMES PAINTED C-3
- 6 METAL AWNING BY B&C AWNING INC. OR EQUAL C-6
- 7 MURPHY STAR LOGO SIGNAGE BY SIGN CONTRACTOR

EXTERIOR FINISHES:

- ACM ACM (3MM THICKNESS) BY FMS
- BRICK THIN BRICK BY FMS
- MTL 20 GA. SHEET METAL (UNLESS NOTED OTHERWISE) BY FMS
- STONE STONE SILL BY FMS

EXTERIOR PAINT/COLORS:

- C-1 THIN BRICK VENEER - LIGHT SANDSTONE VELOUR BY ENDICOTT (WIRE CUT FINISH) WITH ENDURA MAX PREBLENDED GREY COLOR GROUT BY FMS
- C-2 THIN BRICK VENEER - IVORY BLEND VELOUR BY ENDICOTT (WIRE CUT FINISH) WITH ENDURA MAX PREBLENDED GREY COLOR GROUT BY FMS
- C-3 'DORMER BROWN' SW #7521 BY FMS
- C-4 REYNOBOND #4 NATURAL BRUSHED ALUMINUM BY ARCONIC BY FMS
- C-5 THIN BRICK VENEER HERRINGBONE PATTERN - IVORY BLEND VELOUR BY ENDICOTT BY FMS
- C-6 'PROGRAM RED' BY ALPOLIC BY FMS
- C-7 CLEAR ANODIZED ALUMINUM STOREFRONT BY FMS
- C-8 STONE SILL - CONCRETE GRAY CAP BY FMS
- C-9 STONE VENEER - 'ALDERWOOD STACKED STONE' BY ELDORADO STONE BY FMS

PROFESSIONAL IN CHARGE
SCOTT LOUKTS

PROJECT MANAGER
JOSHUA MATOS

QUALITY CONTROL
CHRIS CERBO

DRAWN BY
Author

PROJECT NAME
MURPHY OIL CONVENIENCE STORE
FOUNDERS PKWY & METZLER WAY, CASTLE ROCK COLORADO 80108

FREY MOSS STRUCTURE

1801 Rockdale Industrial Blvd.
Conyers, Georgia 30012
Voice: (800) 366-6385
Fax: (770) 483-6037

FMS JOB NUMBER G23MU0000
FMS MODEL NUMBER XXXXXX

PROJECT NUMBER
20230962.5

SHEET TITLE

ARCHITECTURAL ELEVATIONS (BUILDING)

SHEET NUMBER
A-2 (09 OF 10)

PROTO V4.0 06/28/2024
2800 SQ. FT. BUILDING


SITE DEVELOPMENT PLAN
LOT 2-H, METZLER RANCH FILING NO.3, 1S AMENDMENT
TOWN OF CASTLE ROCK PROJECT NO. SDP24-0001




www.greenbergfarrow.com
251 West 30th Street
10th Floor
New York, New York 10001
t: 917.689.2729

COPYRIGHT NOTICE
This drawing is the property of the above referenced Professional and is not to be used for any purpose other than the specific project and site named herein, and cannot be reproduced in any manner without the express written permission from the Professional.

ISSUE RECORD		
DATE	REV.	DESCRIPTION
01/16/2024		ENTITLEMENT SET
12/08/2024		ENTITLEMENT SET

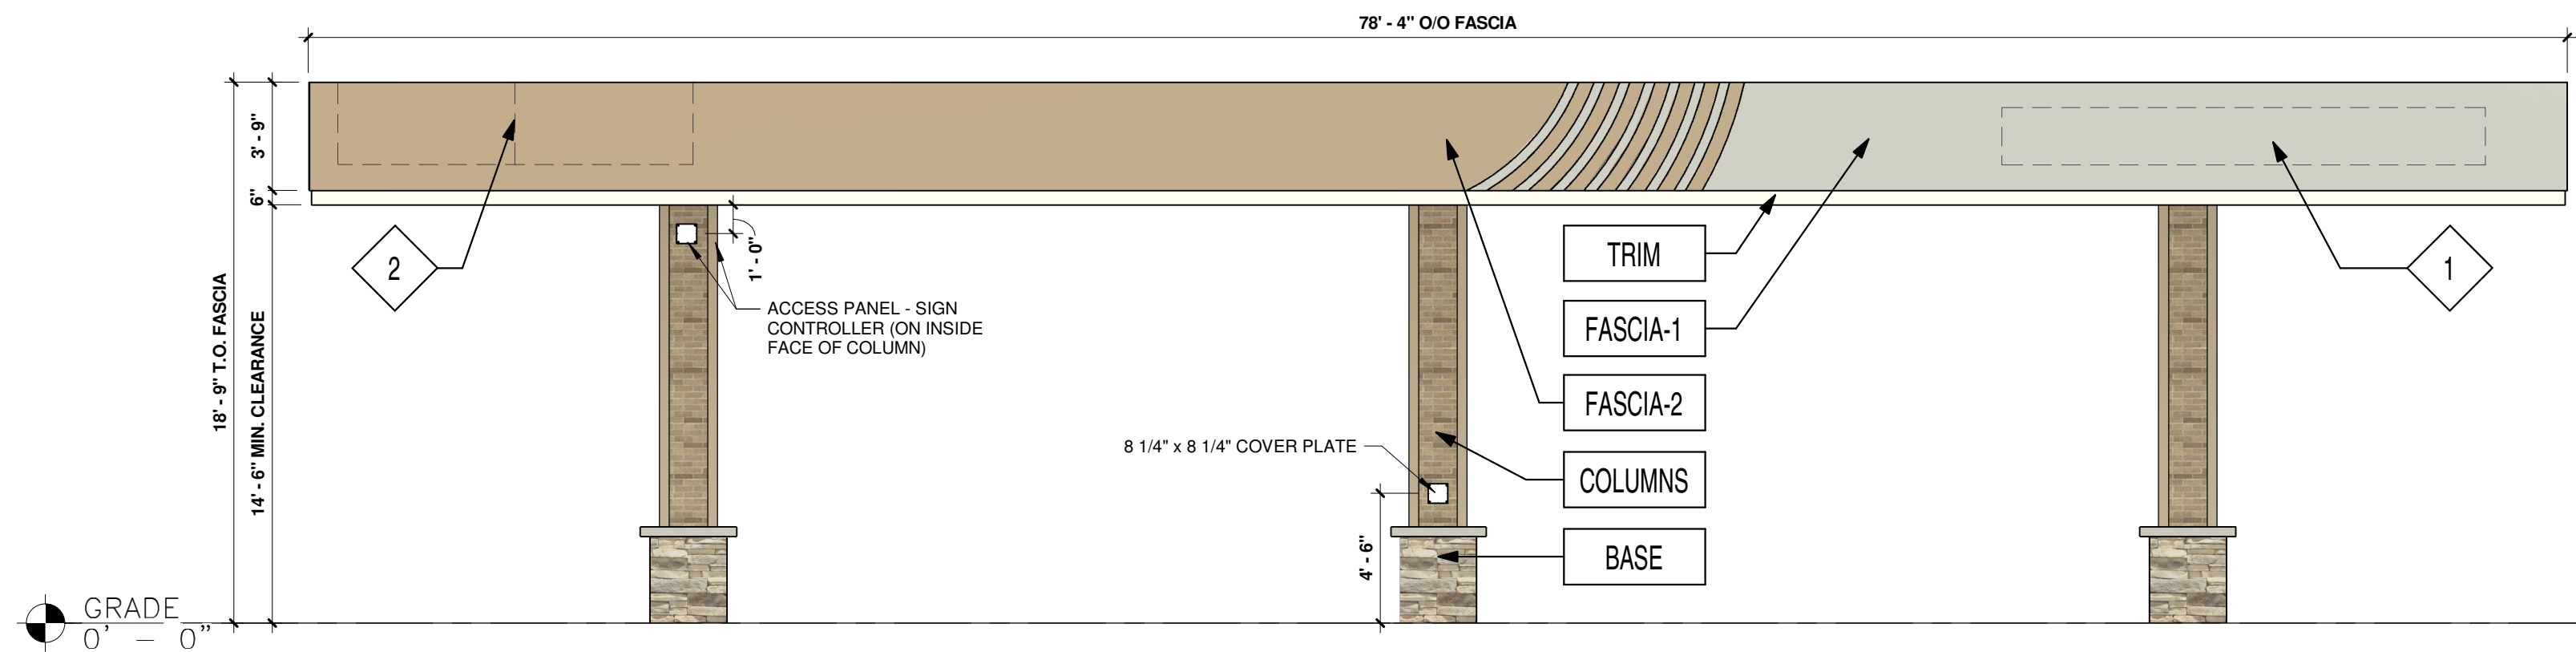


1 SOUTH-EAST ELEVATION
3/16" = 1'-0"

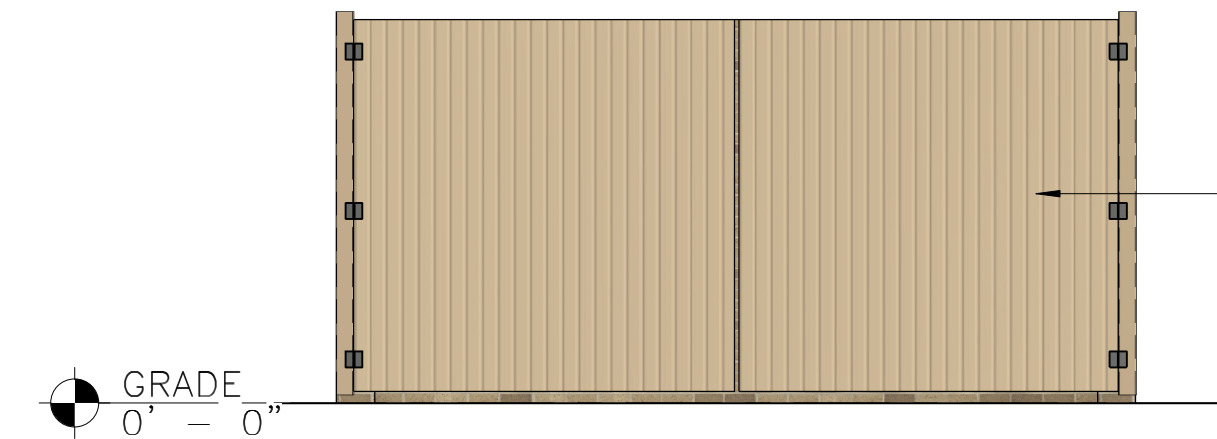


5 DUMSTER ENCLOSER - FRONT ELEVATION
1/4" = 1'-0"


8'-0" HIGH ENCLOSURE - CMU BLOCK W/ BRICK VENEER FINISH - "LIGHT SANDTONE VELOUR" BY ENDICOTT (SUPPLIED AND INSTALLED BY GC)
COMPOSITE FENCE GATES BY "ULTRADECK" FIBERON "VERANDA" OR APPROVED EQUAL. SUPPLIED AND INSTALLED BY GC. GATE PLANKS COLOR TO BE INTEGRAL AND NOT PAINTED. COLOR TO MATCH "DORMER BROWN" SW #7521

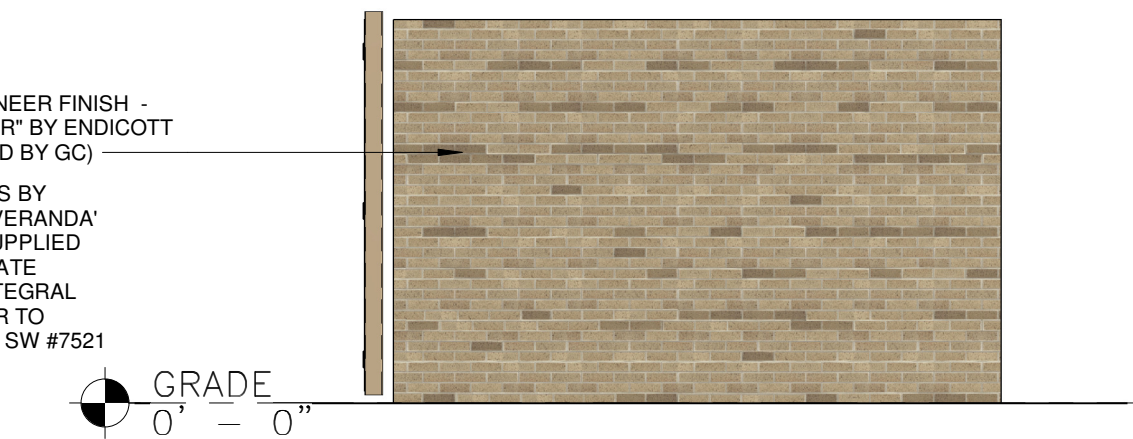

6 DUMSTER ENCLOSER - RIGHT ELEVATION
1/4" = 1'-0"

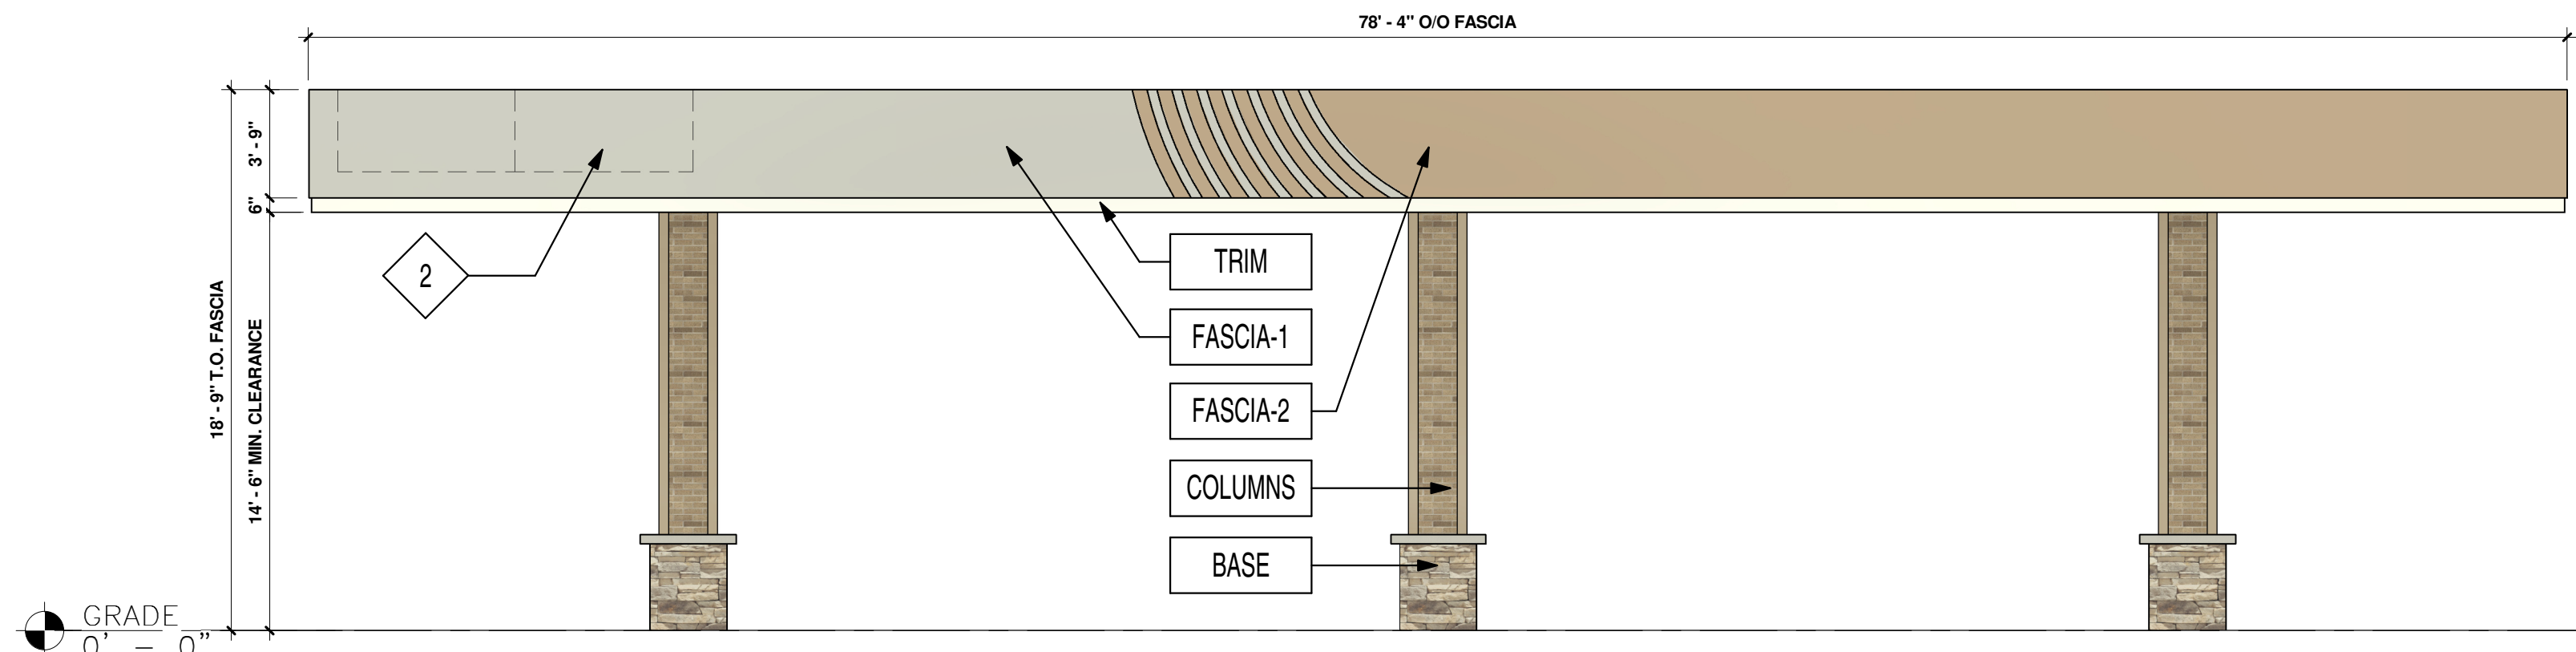


2 NORTH-WEST ELEVATION - METZLER WAY
3/16" = 1'-0"

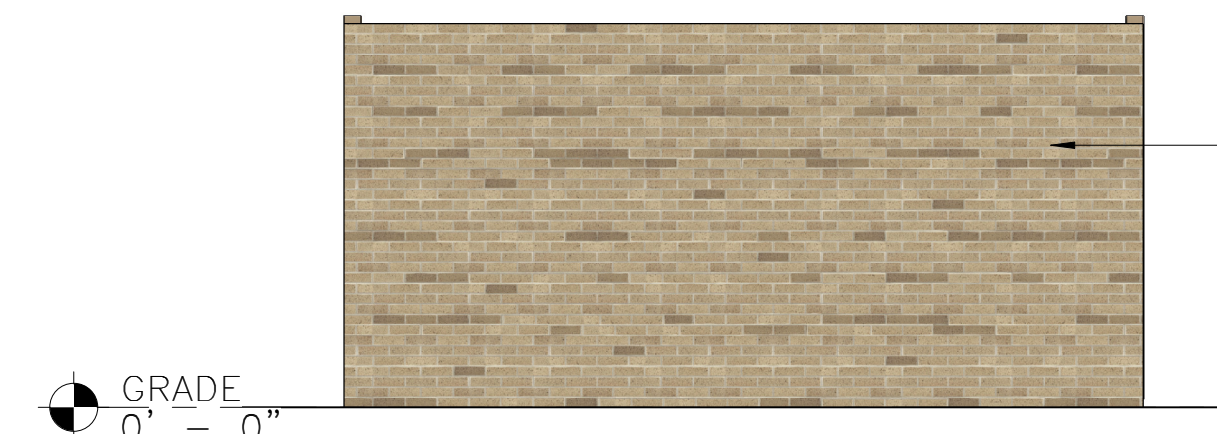


7 DUMSTER ENCLOSER - REAR ELEVATION
1/4" = 1'-0"


8'-0" HIGH ENCLOSURE - CMU BLOCK W/ BRICK VENEER FINISH - "LIGHT SANDTONE VELOUR" BY ENDICOTT (SUPPLIED AND INSTALLED BY GC)

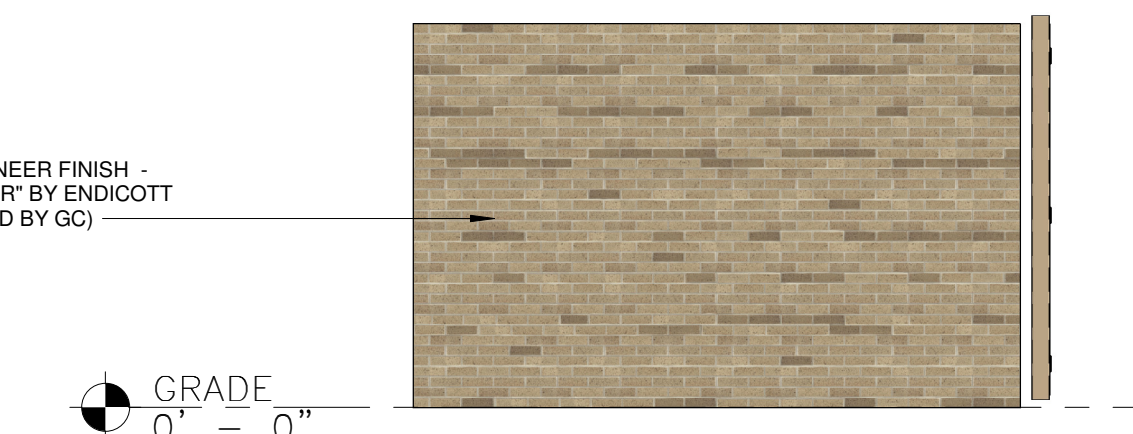

8 DUMSTER ENCLOSER - LEFT ELEVATION
1/4" = 1'-0"

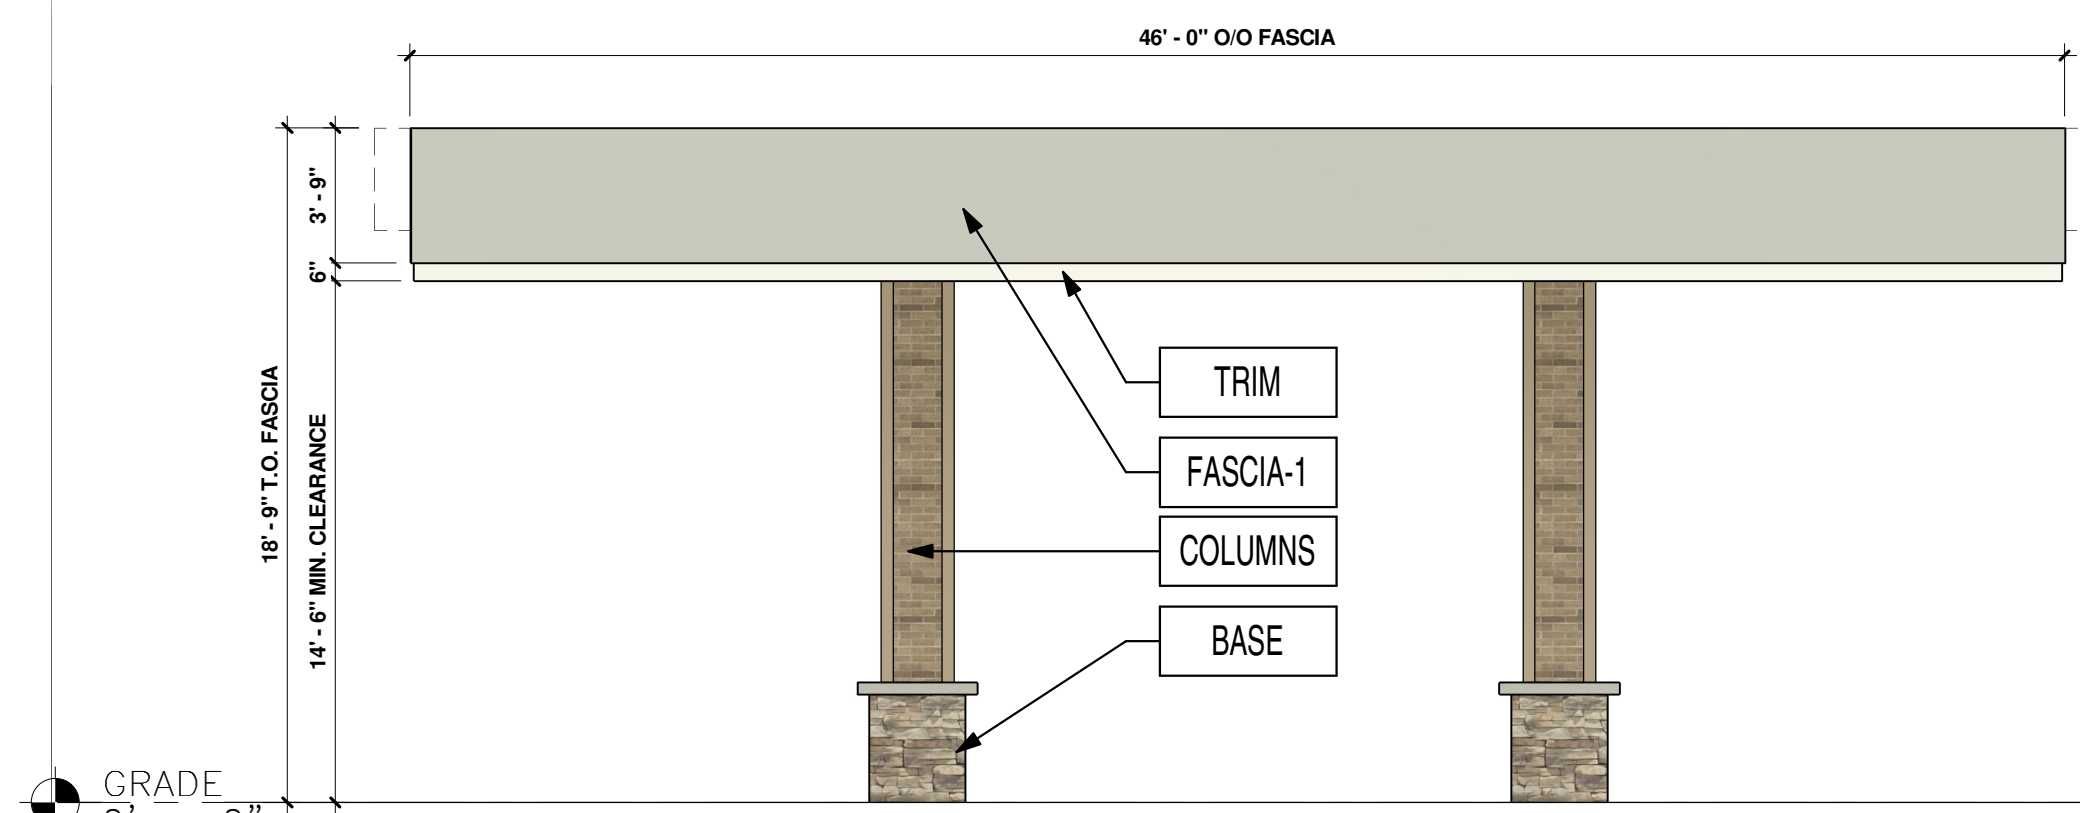

3 NORTH-EAST ELEVATION
3/16" = 1'-0"

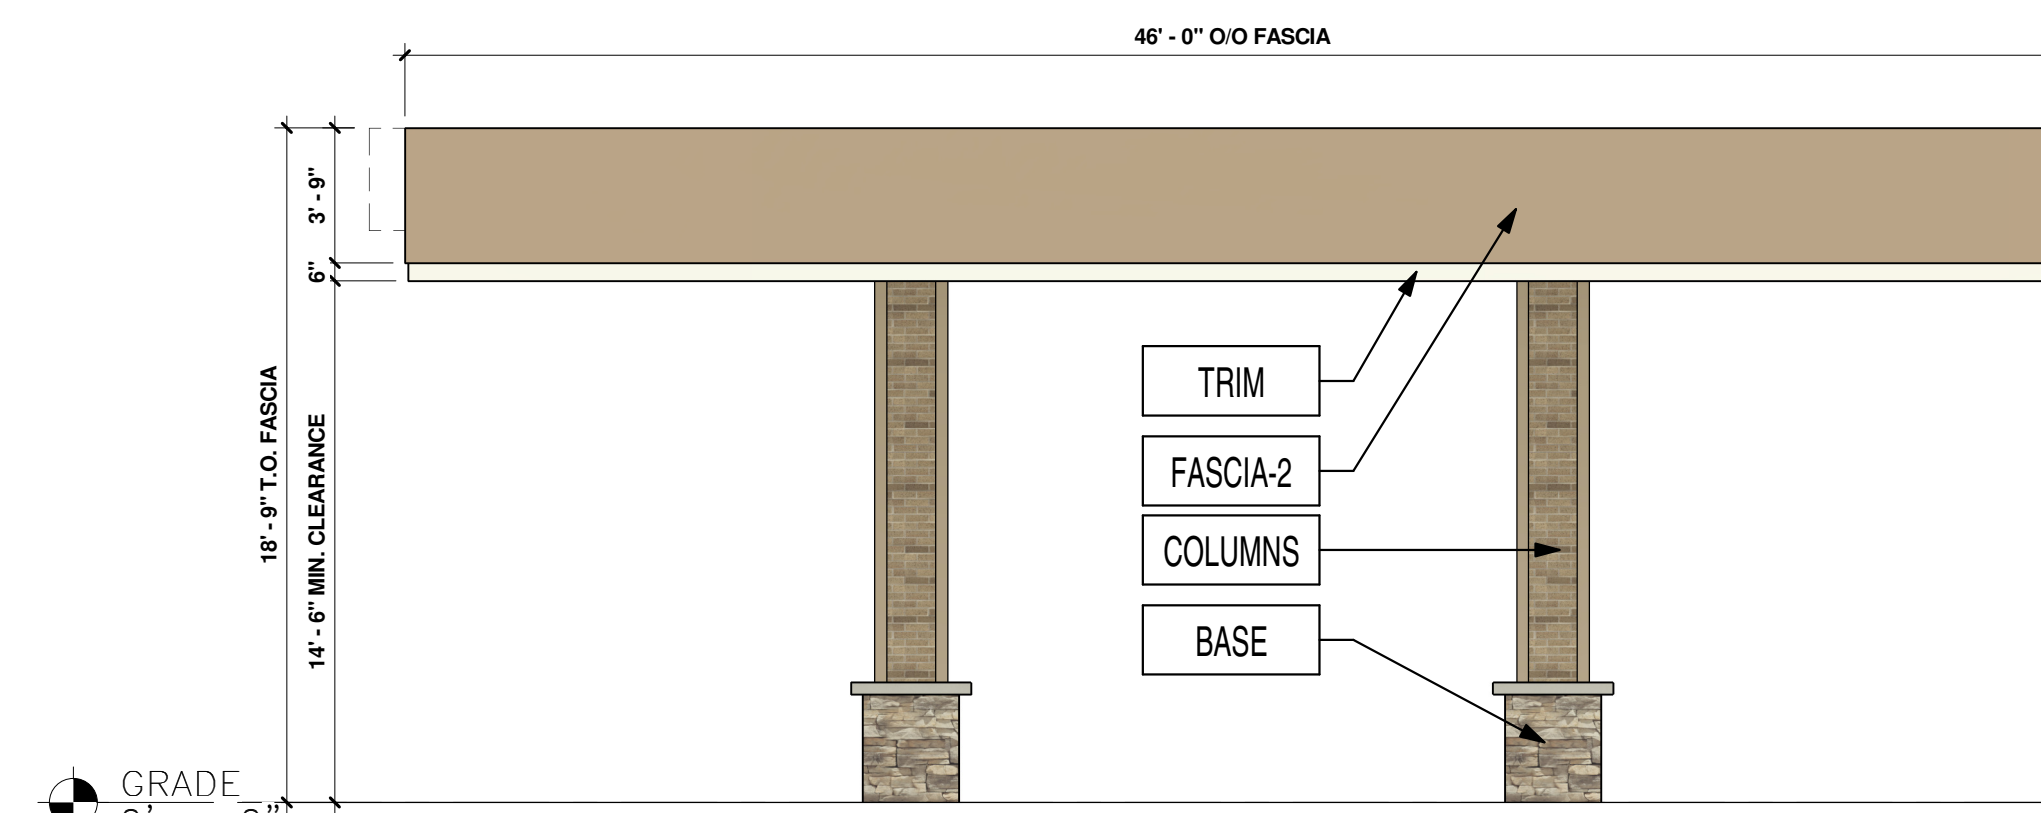

4 SOUTH-WEST ELEVATION - FOUNDERS PKWY
3/16" = 1'-0"

PROFESSIONAL SEAL

PROFESSIONAL IN CHARGE
SCOTT LOINTS
PROJECT MANAGER
JOSHUA MATOS
QUALITY CONTROL
CHRIS CERBO
DRAWN BY
SS

PROJECT NAME



MURPHY OIL FUEL FACILITY CANOPY
FOUNDERS PKWY & METZLER WAY, CASTLE ROCK COLORADO 80108



1801 Rockdale Industrial Blvd.
Conyers, Georgia 30012
Voice: (800) 366-6385
Fax: (770) 483-6037
FMS JOB NUMBER
GXXMXXXXX
FMS MODEL NUMBER
XXXXXX

PROJECT NUMBER
20230962.5

SHEET TITLE

ARCHITECTURAL ELEVATIONS (CANOPY & DUMSTER ENCLOSURE)

SHEET NUMBER

A-3 (10 OF 10)

PROTO V6.1 03/01/2023

FINISH SCHEDULE			KEYED NOTES	
FASCIA-1	ACM (ALUMINUM COMPOSITE MATERIAL)	ACM FASCIA "BRUSHED ALUMINUM"	FURNISHED & INSTALLED BY FMS	1 MURPHY USA LOGO SIGN
FASCIA-2	ACM (ALUMINUM COMPOSITE MATERIAL)	ACM FASCIA "DORMER BROWN" SW #7521	FURNISHED & INSTALLED BY FMS	
TRIM	20 GA. SHEET METAL	6" HT PRE-FINISHED METAL ACCENT BAND "PURE WHITE" SW #7005	FURNISHED & INSTALLED BY FMS	2 CANOPY PRICE SIGNS, CANOPY DESIGNED TO SUPPORT SIGNAGE AT ALL CORNERS
COLUMNS	THIN BRICK VENEER	"LIGHT SANDSTONE VELOUR" BY ENDICOTT	FURNISHED & INSTALLED BY FMS.	
BASE	THIN STONE VENEER	"ALDERWOOD STACKED STONE" BY ELDORADO STONE	FURNISHED & INSTALLED BY FMS.	

SITE DEVELOPMENT PLAN
LOT 2-H, METZLER RANCH FILING NO.3, 1S AMENDMENT
TOWN OF CASTLE ROCK PROJECT NO. SDP24-0001