















ALL SIGNAGES UNDER A SEPARATE PERMIT




www.greenbergfarrow.com  
251 West 30th Street  
10th Floor  
New York, New York 10001  
t: 917.689.2729


**COPYRIGHT NOTICE**  
This drawing is the property of the above referenced Professional and is not to be used for any purpose other than the specific project and site named herein, and cannot be reproduced in any manner without the express written permission from the Professional.

**ISSUE RECORD**

DATE	REV.	DESCRIPTION
01/16/2024		ENTITLEMENT SET
13/08/2024		ENTITLEMENT SET

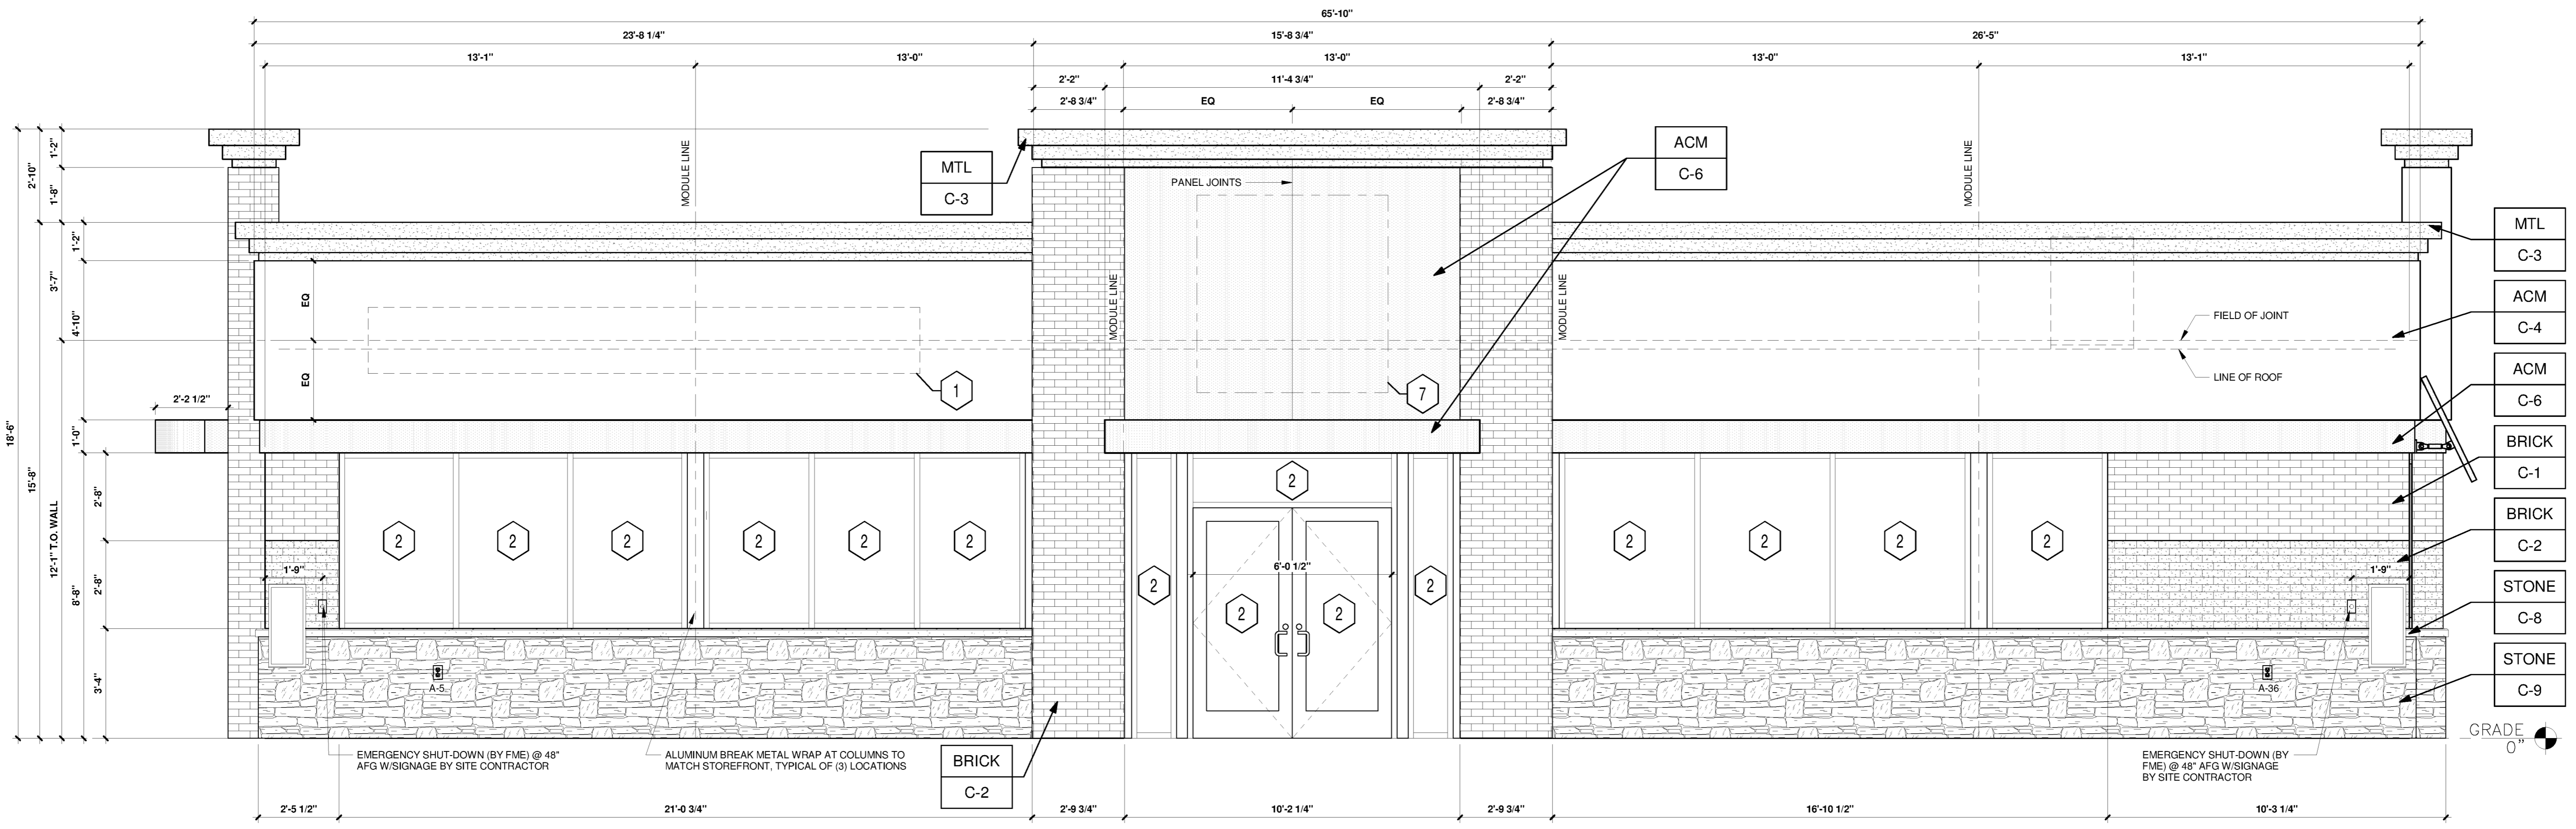

**1 SOUTH-EAST ELEVATION**  
3/8" = 1'-0"

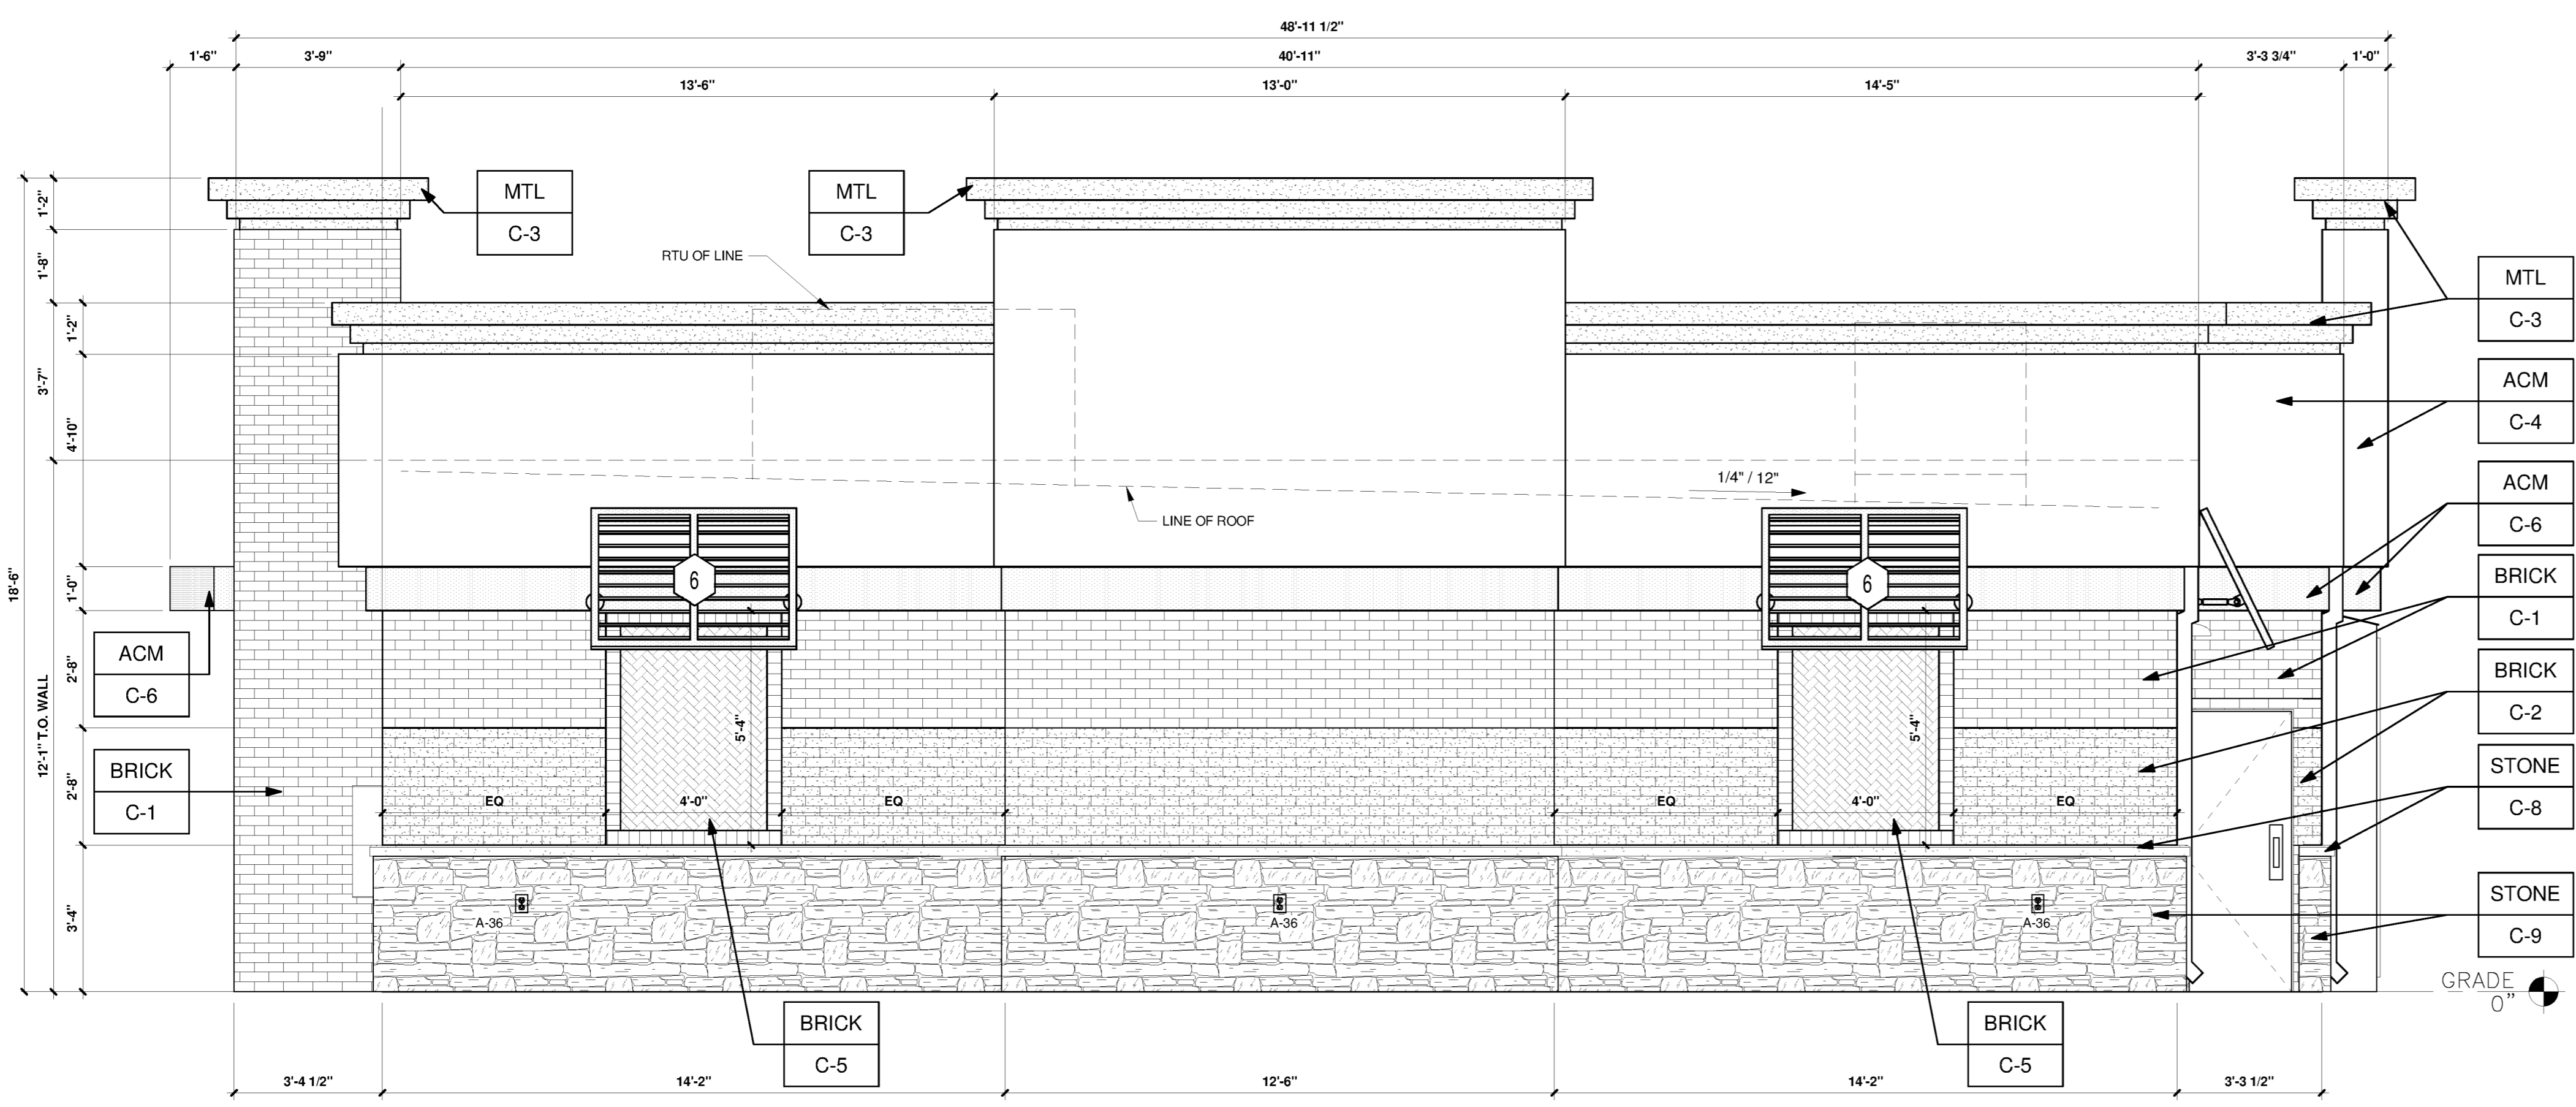

**2 NORTH-EAST ELEVATION**  
3/8" = 1'-0"

**KEYED NOTES:**

- 1 ROUTED LETTER LOGO SIGNAGE BY FMS
- 2 CLEAR ANODIZED ALUMINUM STOREFRONT SYSTEM - KAWNEER, YKK OR EQUAL C-7
- 3 EXTERIOR LIGHTING, REFER TO LIGHTING PLAN SHEET EL2
- 4 4" x 4" PAINTED METAL DOWNSPOUTS C-3
- 5 DOORS (EXTERIOR SIDE) AND DOOR FRAMES PAINTED C-3
- 6 METAL AWNING BY B&C AWNING INC. OR EQUAL C-6
- 7 MURPHY STAR LOGO SIGNAGE BY SIGN CONTRACTOR

**EXTERIOR FINISHES:**

- ACM ACM (3MM THICKNESS) BY FMS
- BRICK THIN BRICK BY FMS
- MTL 20 GA. SHEET METAL (UNLESS NOTED OTHERWISE) BY FMS
- STONE STONE SILL BY FMS

**EXTERIOR PAINT/COLORS:**

- C-1 THIN BRICK VENEER - LIGHT STONE VELOUR BY ENDICOTT (WIRE CUT FINISH) WITH ENDURA MAX PREBLENDED GREY COLOR GROUT BY FMS
- C-2 THIN BRICK VENEER - IVORY BLEND VELOUR BY ENDICOTT (WIRE CUT FINISH) WITH ENDURA MAX PREBLENDED GREY COLOR GROUT BY FMS
- C-3 DORMER BROWN SW #7521 BY FMS
- C-4 REYNOBOND #4 NATURAL BRUSHED ALUMINUM BY ARCONIC BY FMS
- C-5 THIN BRICK VENEER HERRINGBONE PATTERN - IVORY BLEND VELOUR BY ENDICOTT BY FMS
- C-6 'PROGRAM RED' BY ALPOLIC BY FMS
- C-7 CLEAR ANODIZED ALUMINUM STOREFRONT BY FMS
- C-8 STONE SILL - CONCRETE GRAY CAP BY FMS
- C-9 STONE VENEER - 'ALDERWOOD STACKED STONE' BY ELDRADO STONE BY FMS

**PROFESSIONAL SEAL**

**PROFESSIONAL IN CHARGE**

SCOTT LONJITS

**PROJECT MANAGER**

JOSHUA MATOS

**QUALITY CONTROL**

CHRIS CERBO

**DRAWN BY**

ST

**PROJECT NAME**

**MURPHY USA**

**MURPHY OIL CONVENIENCE STORE**  
FOUNDERS PKWY & METZLER WAY,  
CASTLE ROCK COLORADO 80108



1801 Rockdale Industrial Blvd.  
Conyers, Georgia 30012  
Voice: (800) 366-6385  
Fax: (770) 483-6037

FMS JOB NUMBER  
G23MU00000  
FMS MODEL NUMBER  
XXXXXX

**PROJECT NUMBER**  
20230962.5

**SHEET TITLE**

**ARCHITECTURAL ELEVATIONS (BUILDING)**

**SHEET NUMBER**

**A-1 (08 OF 10)**

**PROTO V4.0 06/28/2024**  
2800 SQ. FT. BUILDING

SITE DEVELOPMENT PLAN  
LOT 2-H, METZLER RANCH NO.3, 1S AMENDMENT  
TOWN OF CASTLE ROCK PROJECT NO. SDP24-0001


ALL SIGNAGES UNDER A SEPARATE PERMIT




**COPYRIGHT NOTICE**  
This drawing is the property of the above referenced Professional and is not to be used for any purpose other than the specific project and site named herein, and cannot be reproduced in any manner without the express written permission from the Professional.

**ISSUE RECORD**

DATE	REV.	DESCRIPTION
01/16/2024		ENTITLEMENT SET
13/08/2024		ENTITLEMENT SET

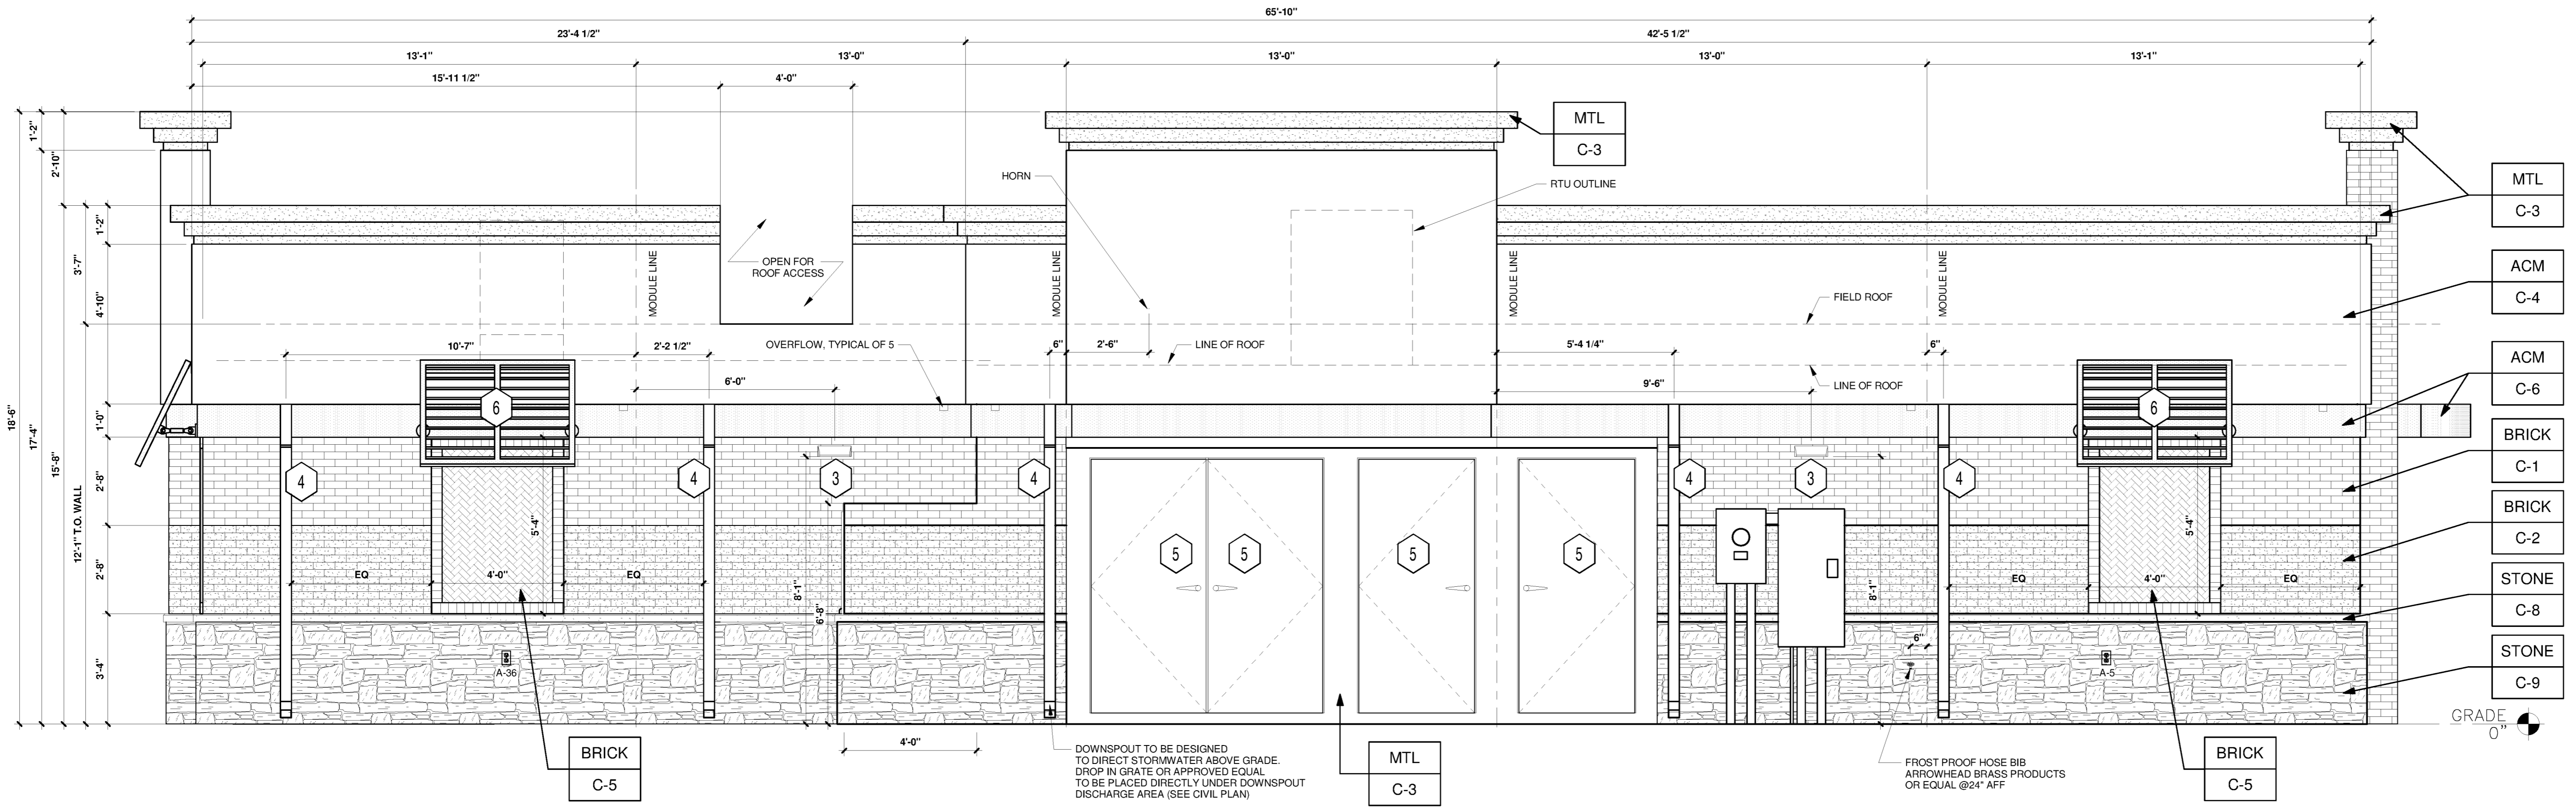

**1 NORTH-WEST ELEVATION - METZLER WAY**  
3/8" = 1'-0"

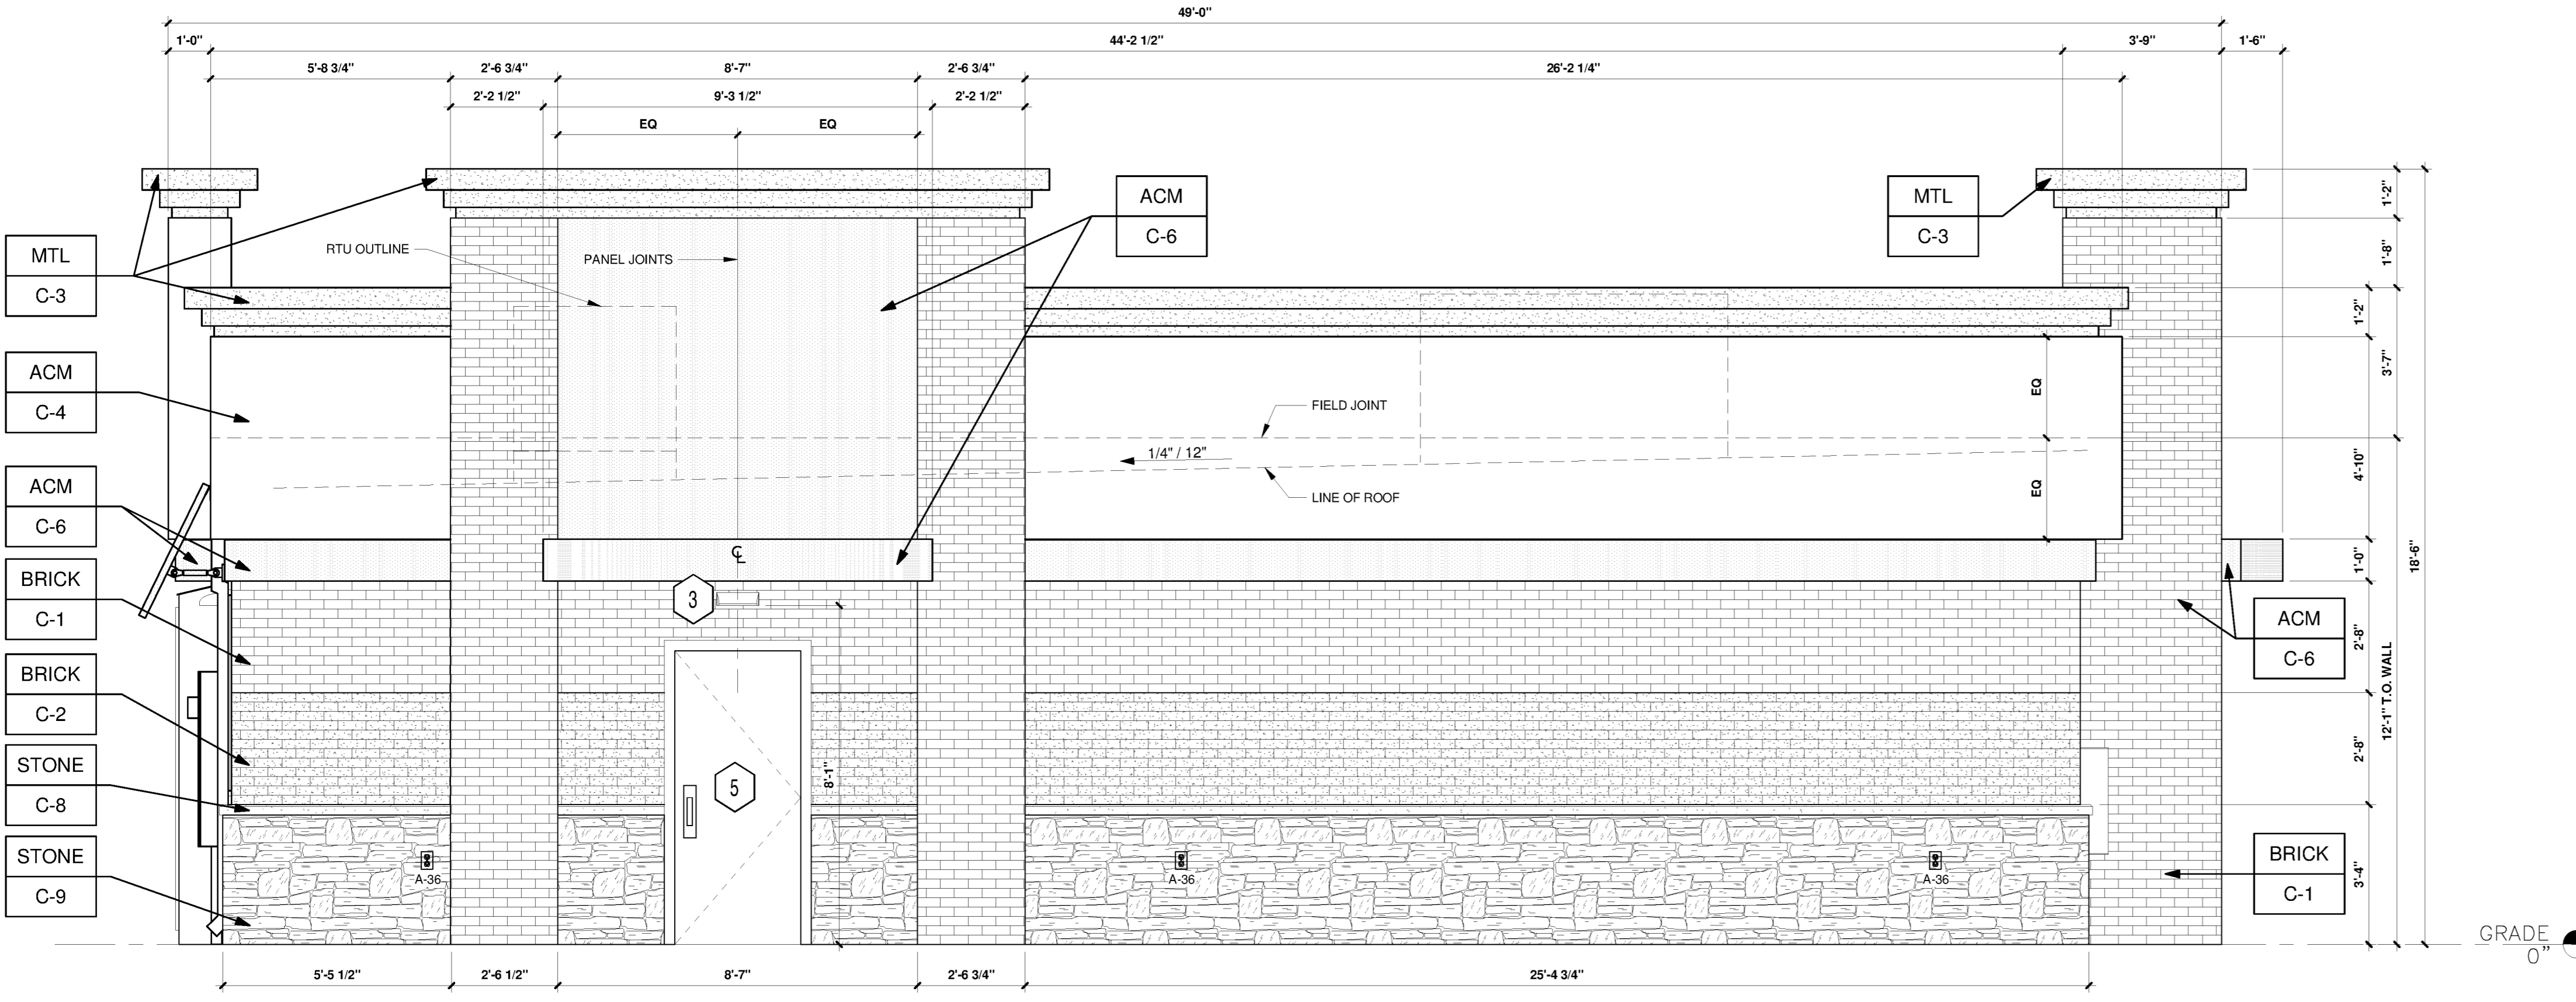

**2 SOUTH-WEST ELEVATION - FOUNDERS PKWY**  
3/8" = 1'-0"

- KEYED NOTES:**
- 1 ROUTED LETTER LOGO SIGNAGE BY FMS
  - 2 CLEAR ANODIZED ALUMINUM STOREFRONT SYSTEM - KAWNEER, YKK OR EQUAL C-7
  - 3 EXTERIOR LIGHTING, REFER TO LIGHTING PLAN SHEET EL2
  - 4 4" x 4" PAINTED METAL DOWNSPOUTS C-3
  - 5 DOORS (EXTERIOR SIDE) AND DOOR FRAMES PAINTED C-3
  - 6 METAL AWNING BY B&C AWNING INC. OR EQUAL C-6
  - 7 MURPHY STAR LOGO SIGNAGE BY SIGN CONTRACTOR
- EXTERIOR FINISHES:**
- ACM ACM (3MM THICKNESS) BY FMS
  - BRICK THIN BRICK BY FMS
  - MTL 20 GA. SHEET METAL (UNLESS NOTED OTHERWISE) BY FMS
  - STONE STONE SILL BY FMS
- EXTERIOR PAINT/COLORS:**
- C-1 THIN BRICK VENEER - LIGHT SANDSTONE VELOUR BY ENDICOTT (WIRE CUT FINISH) WITH ENDURA MAX PREBLEND GREY COLOR GROUT BY FMS
  - C-2 THIN BRICK VENEER - IVORY BLEND VELOUR BY ENDICOTT (WIRE CUT FINISH) WITH ENDURA MAX PREBLEND GREY COLOR GROUT BY FMS
  - C-3 'DORMER BROWN' SW #7521 BY FMS
  - C-4 REYNOBOND #4 NATURAL BRUSHED ALUMINUM BY ARCONIC BY FMS
  - C-5 THIN BRICK VENEER - HERRINGBONE PATTERN - IVORY BLEND VELOUR BY ENDICOTT BY FMS
  - C-6 'PROGRAM RED' BY ALPOLIC BY FMS
  - C-7 CLEAR ANODIZED ALUMINUM STOREFRONT BY FMS
  - C-8 STONE SILL - CONCRETE GRAY CAP BY FMS
  - C-9 STONE VENEER - 'ALDERWOOD STACKED STONE' BY ELDRADO STONE BY FMS

**PROFESSIONAL IN CHARGE**  
SCOTT LONITS

**PROJECT MANAGER**  
JOSHUA MATOS

**QUALITY CONTROL**  
CHRIS CERBO

**DRAWN BY**  
Author

**PROJECT NAME**  
**MURPHY USA**  
**MURPHY OIL CONVENIENCE STORE**  
FOUNDERS PKWY & METZLER WAY, CASTLE ROCK COLORADO 80108



1801 Rockdale Industrial Blvd.  
Conyers, Georgia 30012  
Voice: (800) 366-6385  
Fax: (770) 483-6037

FMS JOB NUMBER  
G23MU00000  
FMS MODEL NUMBER  
XXXXXX

**PROJECT NUMBER**  
**20230962.5**

**SHEET TITLE**

**ARCHITECTURAL ELEVATIONS (BUILDING)**

**SHEET NUMBER**

**A-2 (09 OF 10)**

**PROTO V4.0 06/28/2024**  
**2800 SQ. FT. BUILDING**

SITE DEVELOPMENT PLAN  
LOT 2-H, METZLER PLAN FILING NO.3, 1S AMENDMENT  
TOWN OF CASTLE ROCK PROJECT NO. SDP24-0001


ALL SIGNAGES UNDER A SEPARATE PERMIT




www.greenbergfarrow.com  
 251 West 30th Street  
 10th Floor  
 New York, New York 10001  
 t: 917.689.2729

**COPYRIGHT NOTICE**  
 This drawing is the property of the above referenced Professional and is not to be used for any purpose other than the specific project and site named herein, and cannot be reproduced in any manner without the express written permission from the Professional.


ISSUE RECORD		
DATE	REV.	DESCRIPTION
01/16/2024		ENTITLEMENT SET
13/08/2024		ENTITLEMENT SET

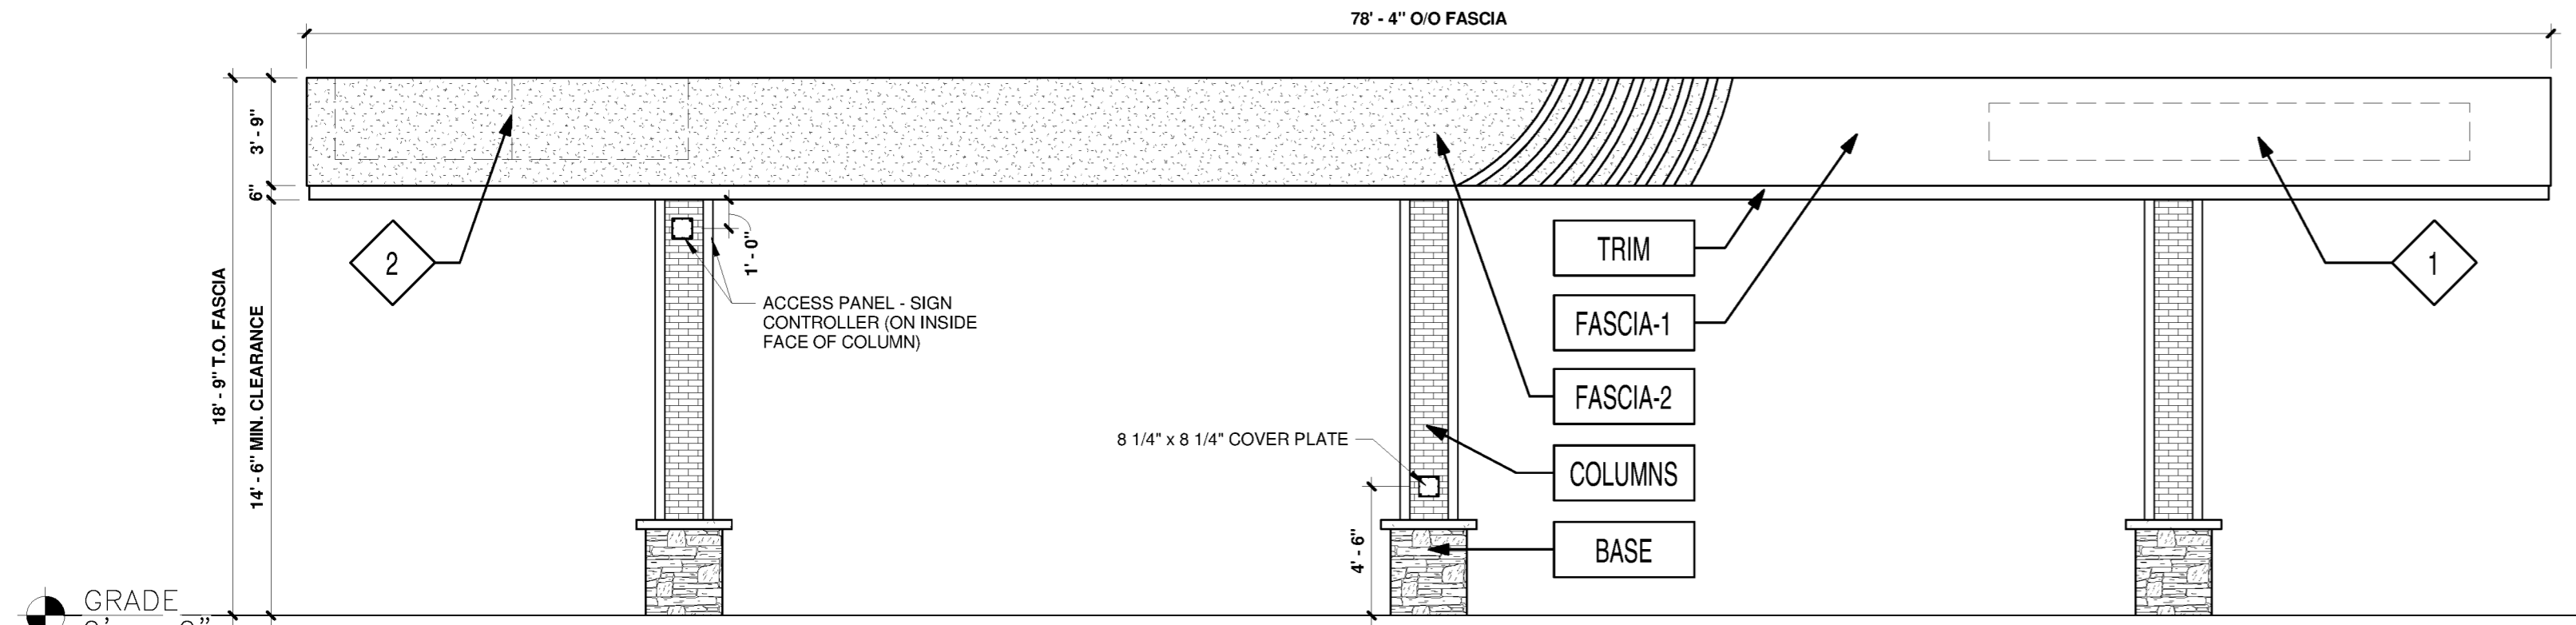


**1 SOUTH-EAST ELEVATION**  
 3/16" = 1'-0"

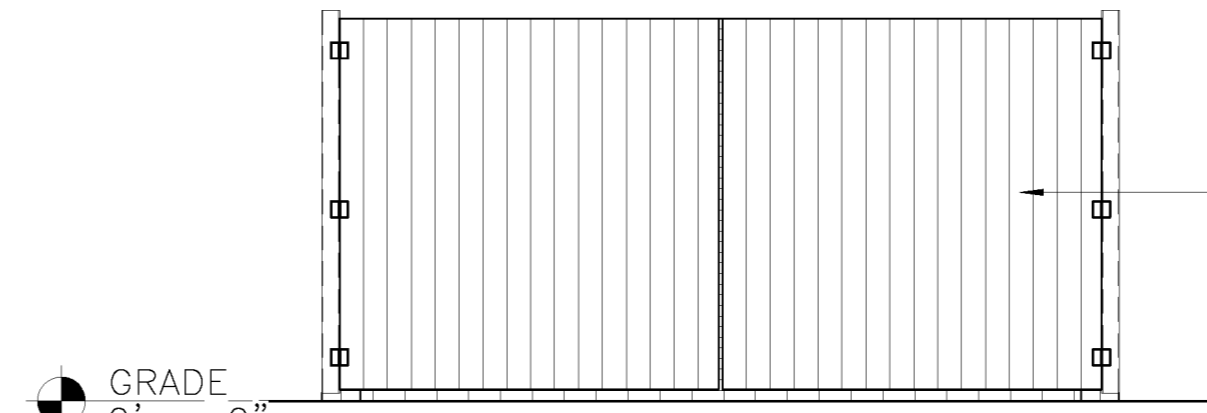


**5 DUMSTER ENCLOSER - FRONT ELEVATION**  
 1/4" = 1'-0"

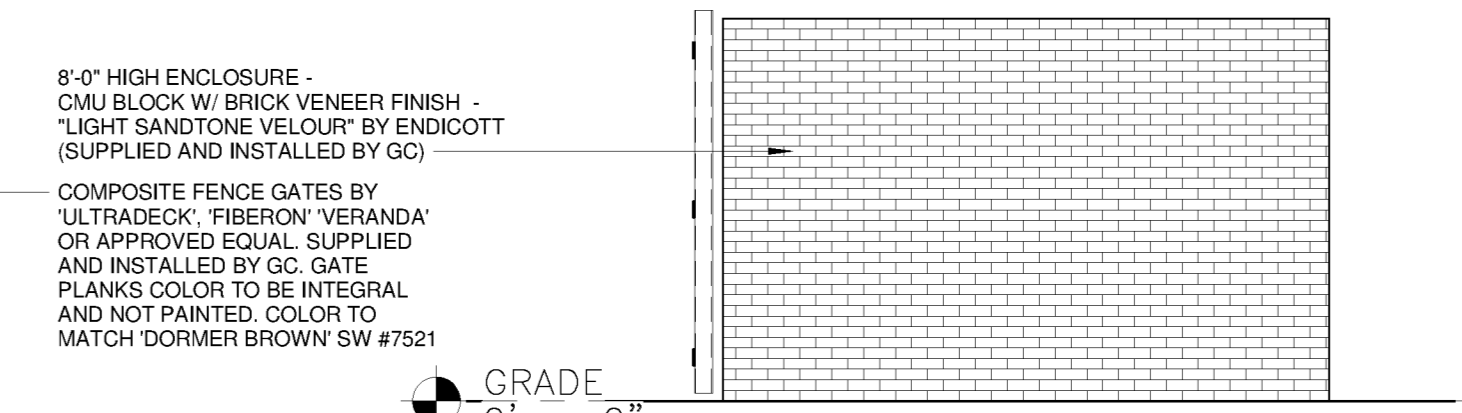


**6 DUMSTER ENCLOSER - RIGHT ELEVATION**  
 1/4" = 1'-0"

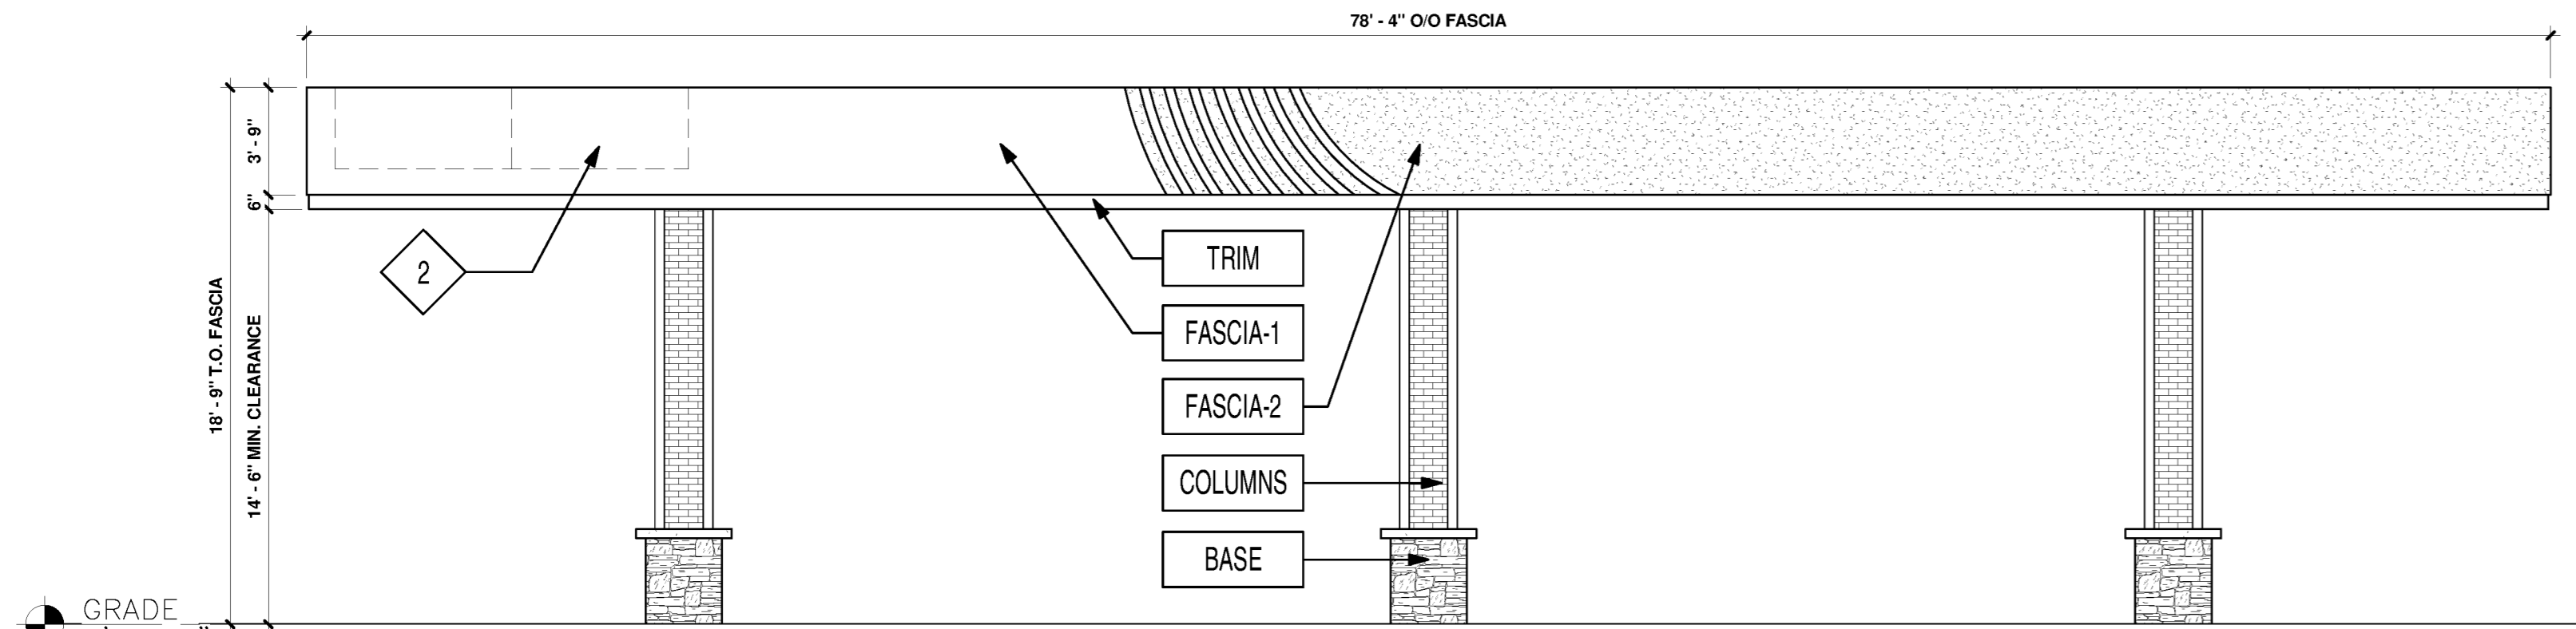


**2 NORTH-WEST ELEVATION - METZLER WAY**  
 3/16" = 1'-0"

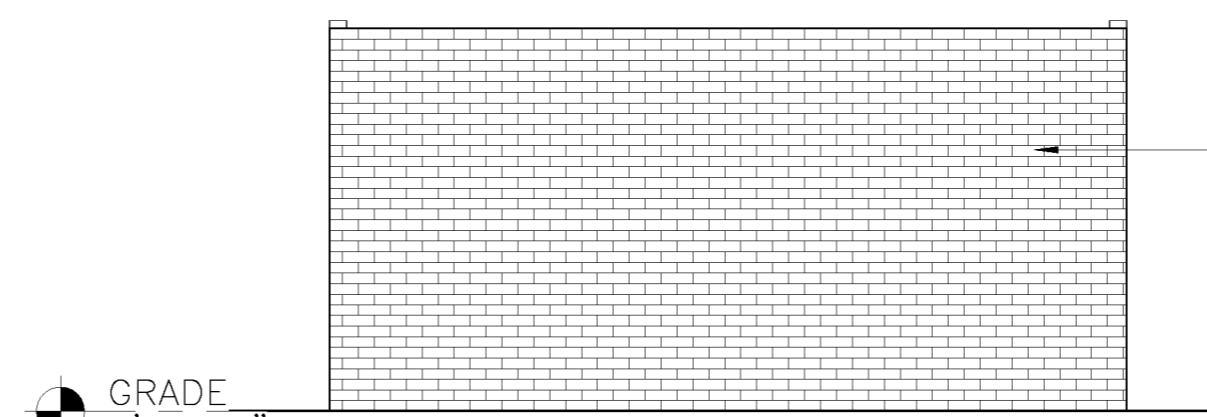


**7 DUMSTER ENCLOSER - REAR ELEVATION**  
 1/4" = 1'-0"

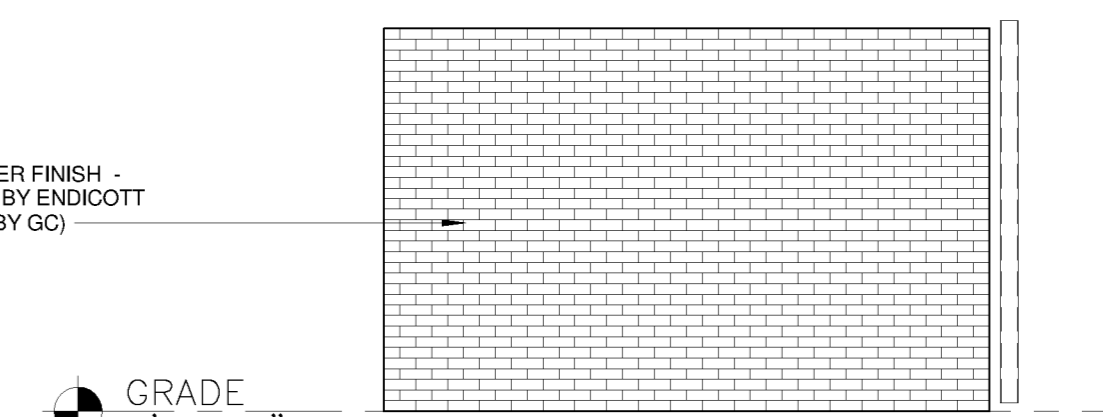

**8 DUMSTER ENCLOSER - LEFT ELEVATION**  
 1/4" = 1'-0"

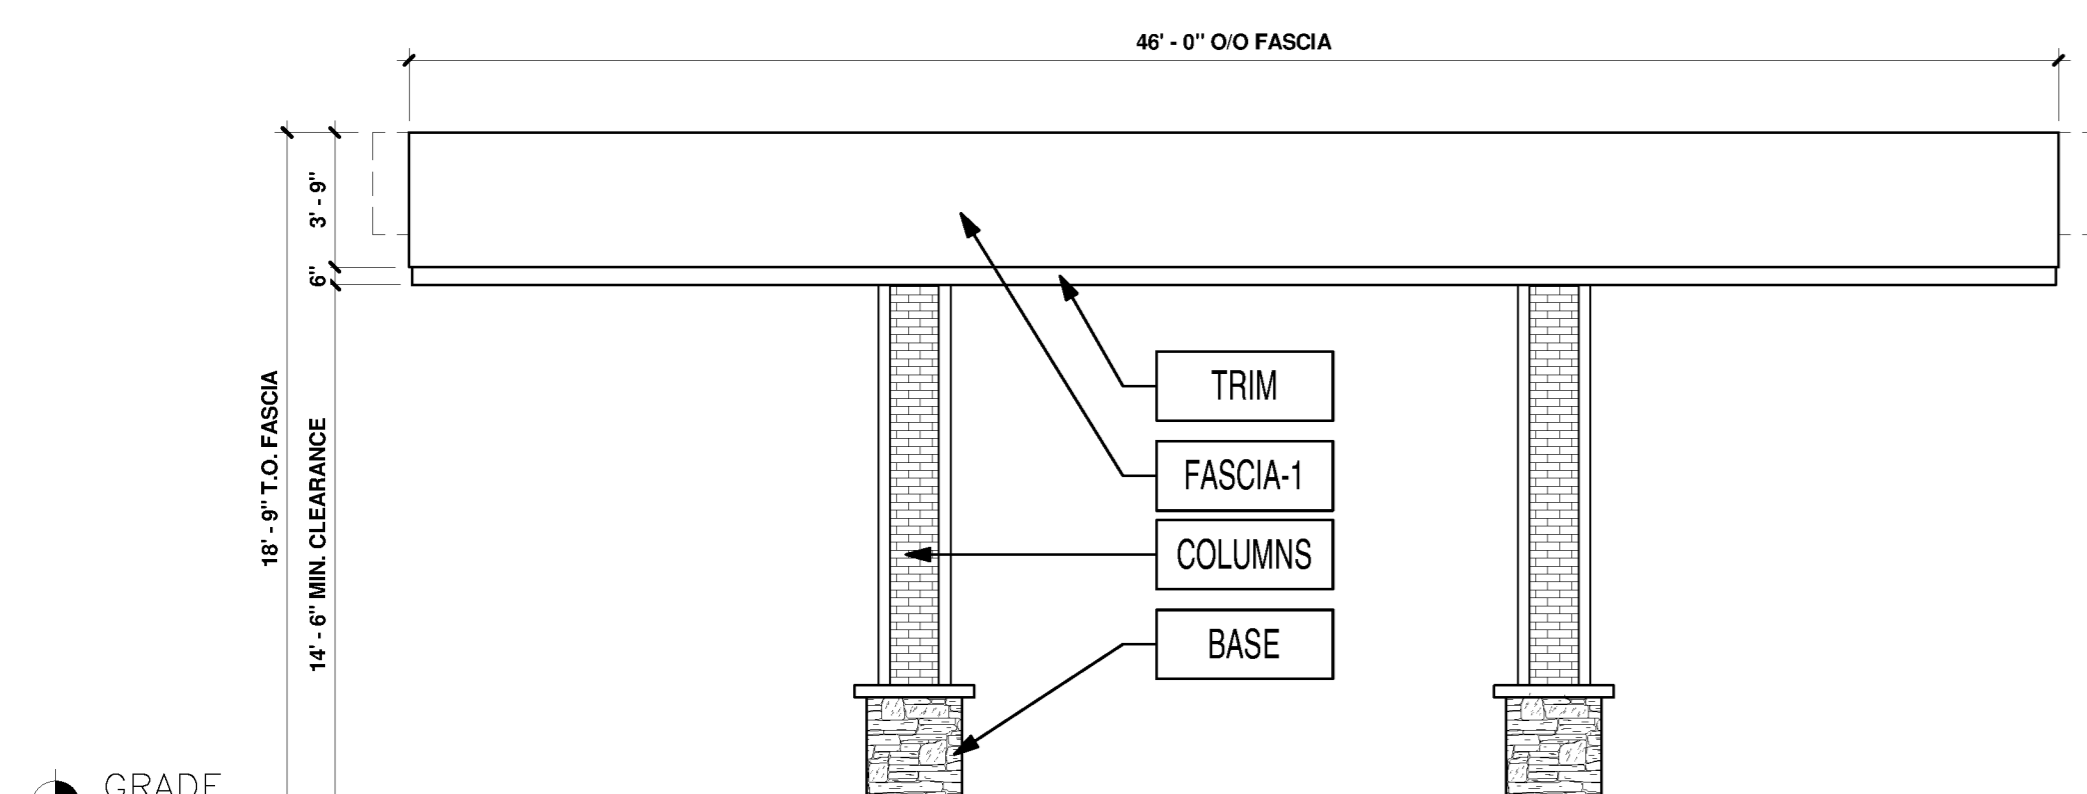

**3 NORTH-EAST ELEVATION**  
 3/16" = 1'-0"

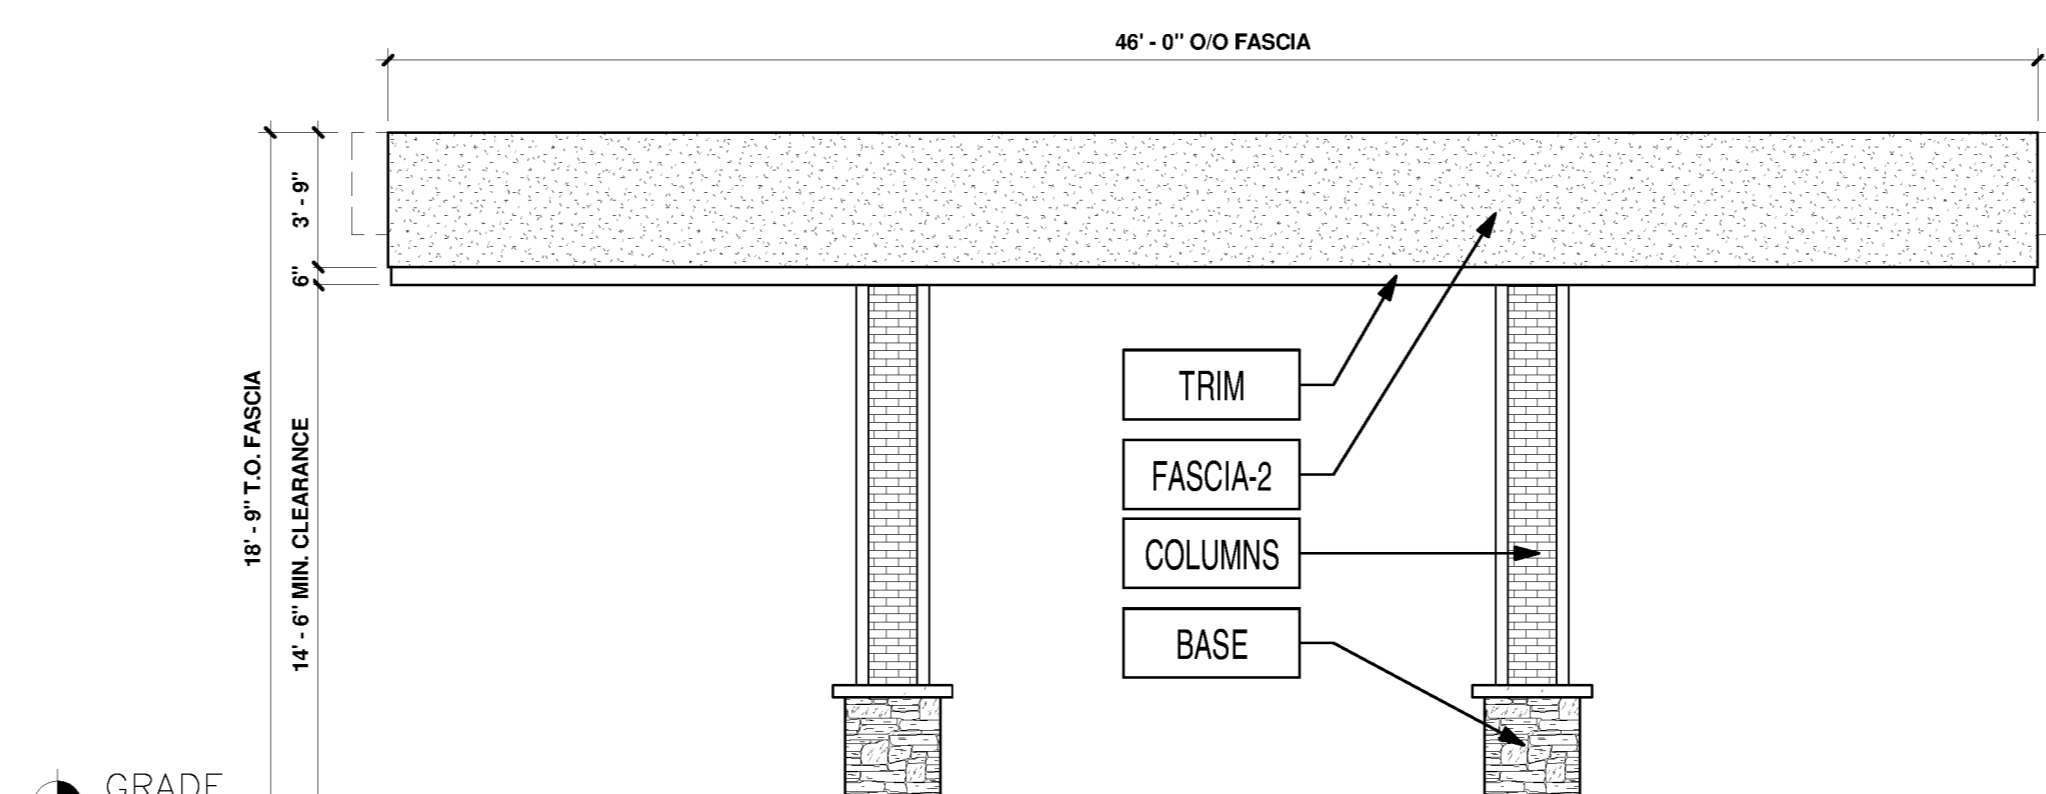

**4 SOUTH-WEST ELEVATION - FOUNDERS PKWY**  
 3/16" = 1'-0"

FINISH SCHEDULE			KEYED NOTES
FASCIA-1	ACM (ALUMINUM COMPOSITE MATERIAL)	ACM FASCIA "BRUSHED ALUMINUM"	FURNISHED & INSTALLED BY FMS
FASCIA-2	ACM (ALUMINUM COMPOSITE MATERIAL)	ACM FASCIA "DORMER BROWN" SW #7521	FURNISHED & INSTALLED BY FMS
TRIM	20 GA. SHEET METAL	6" HT PRE-FINISHED METAL ACCENT BAND "PURE WHITE" SW #7005	FURNISHED & INSTALLED BY FMS
COLUMNS	THIN BRICK VENEER	"LIGHT SANDSTONE VELOUR" BY ENDICOTT	FURNISHED & INSTALLED BY FMS.
BASE	THIN STONE VENEER	"ALDERWOOD STACKED STONE" BY ELDORADO STONE	FURNISHED & INSTALLED BY FMS.

1	MURPHY USA LOGO SIGN
2	CANOPY PRICE SIGNS, CANOPY DESIGNED TO SUPPORT SIGNAGE AT ALL CORNERS

PROFESSIONAL SEAL

PROFESSIONAL IN CHARGE  
 SCOTT LOUNTS  
 PROJECT MANAGER  
 JOSHUA MATOS  
 QUALITY CONTROL  
 CHRIS CERBO  
 DRAWN BY  
 SS

PROJECT NAME  
**MURPHY USA**

**MURPHY OIL FUEL FACILITY CANOPY**  
 FOUNDERS PKWY & METZLER WAY, CASTLE ROCK COLORADO 80108

**FREY MOSS STRUCTURE**

1801 Rockdale Industrial Blvd.  
 Conyers, Georgia 30012  
 Voice: (800) 266-6385  
 Fax: (770) 483-6037

FMS JOB NUMBER  
 GXXMXXXXXX  
 FMS MODEL NUMBER  
 XXXXXX

PROJECT NUMBER  
**20230962.5**

SHEET TITLE  
**ARCHITECTURAL ELEVATIONS (CANOPY & DUMSTER ENCLOSURE)**

SHEET NUMBER  
**A-3 (10 OF 10)**

PROTO V6.1 03/01/2023

SITE DEVELOPMENT PLAN  
 LOT 2-H, METZLER RANCH NO.3, 1S AMENDMENT  
 TOWN OF CASTLE ROCK PROJECT NO. SDP24-0001